



917.570.5105
NARELLE@EARTHLINK.NET

OUTSIDE MULLINGAR

BY: JOHN PATRICK SHANLEY
DIRECTED BY: JOHN RUBIN

PRODUCTION TEAM

SCENIC DESIGNER	NARELLE SISSONS
LIGHTING DESIGNER	MICHAEL GIANNITTI
COSTUME DESIGNER	BARBARA BELL
SOUND DESIGNER	RYAN RUMERY
MEDIA DESIGNER	KEVIN RAMSER
TECHNICAL DIRECTOR	KEVIN JOSEPH
DRAFTINGS BY	JOEY SARNO

The designer is responsible for the visual aspects of the production only, and the specification of the designer's designs relate solely to the appearance of the design and not to matters of safety. The designer agrees to make prompt correcting alterations to any specifications found to be incompatible with proper safety precautions

DORSET THEATRE FESTIVAL


DATE: 04-21-2015

SCALE: 0'-1/4" = 1'-0"


REVISION #1: 05-01-2015
REVISION #2: 05-15-2015
REVISION #3: 05-25-2015

GROUND PLAN

PLATE NO.

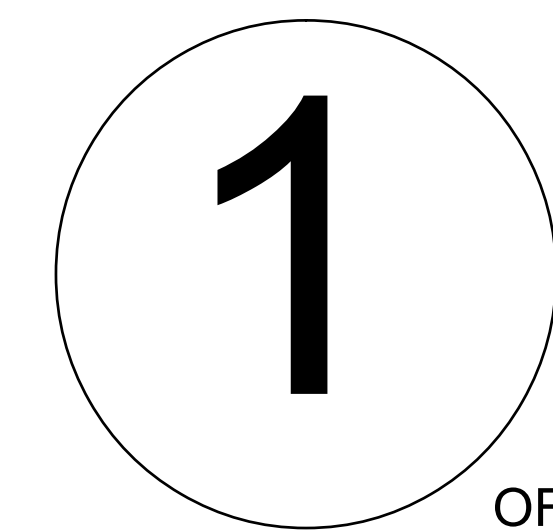

OF 6

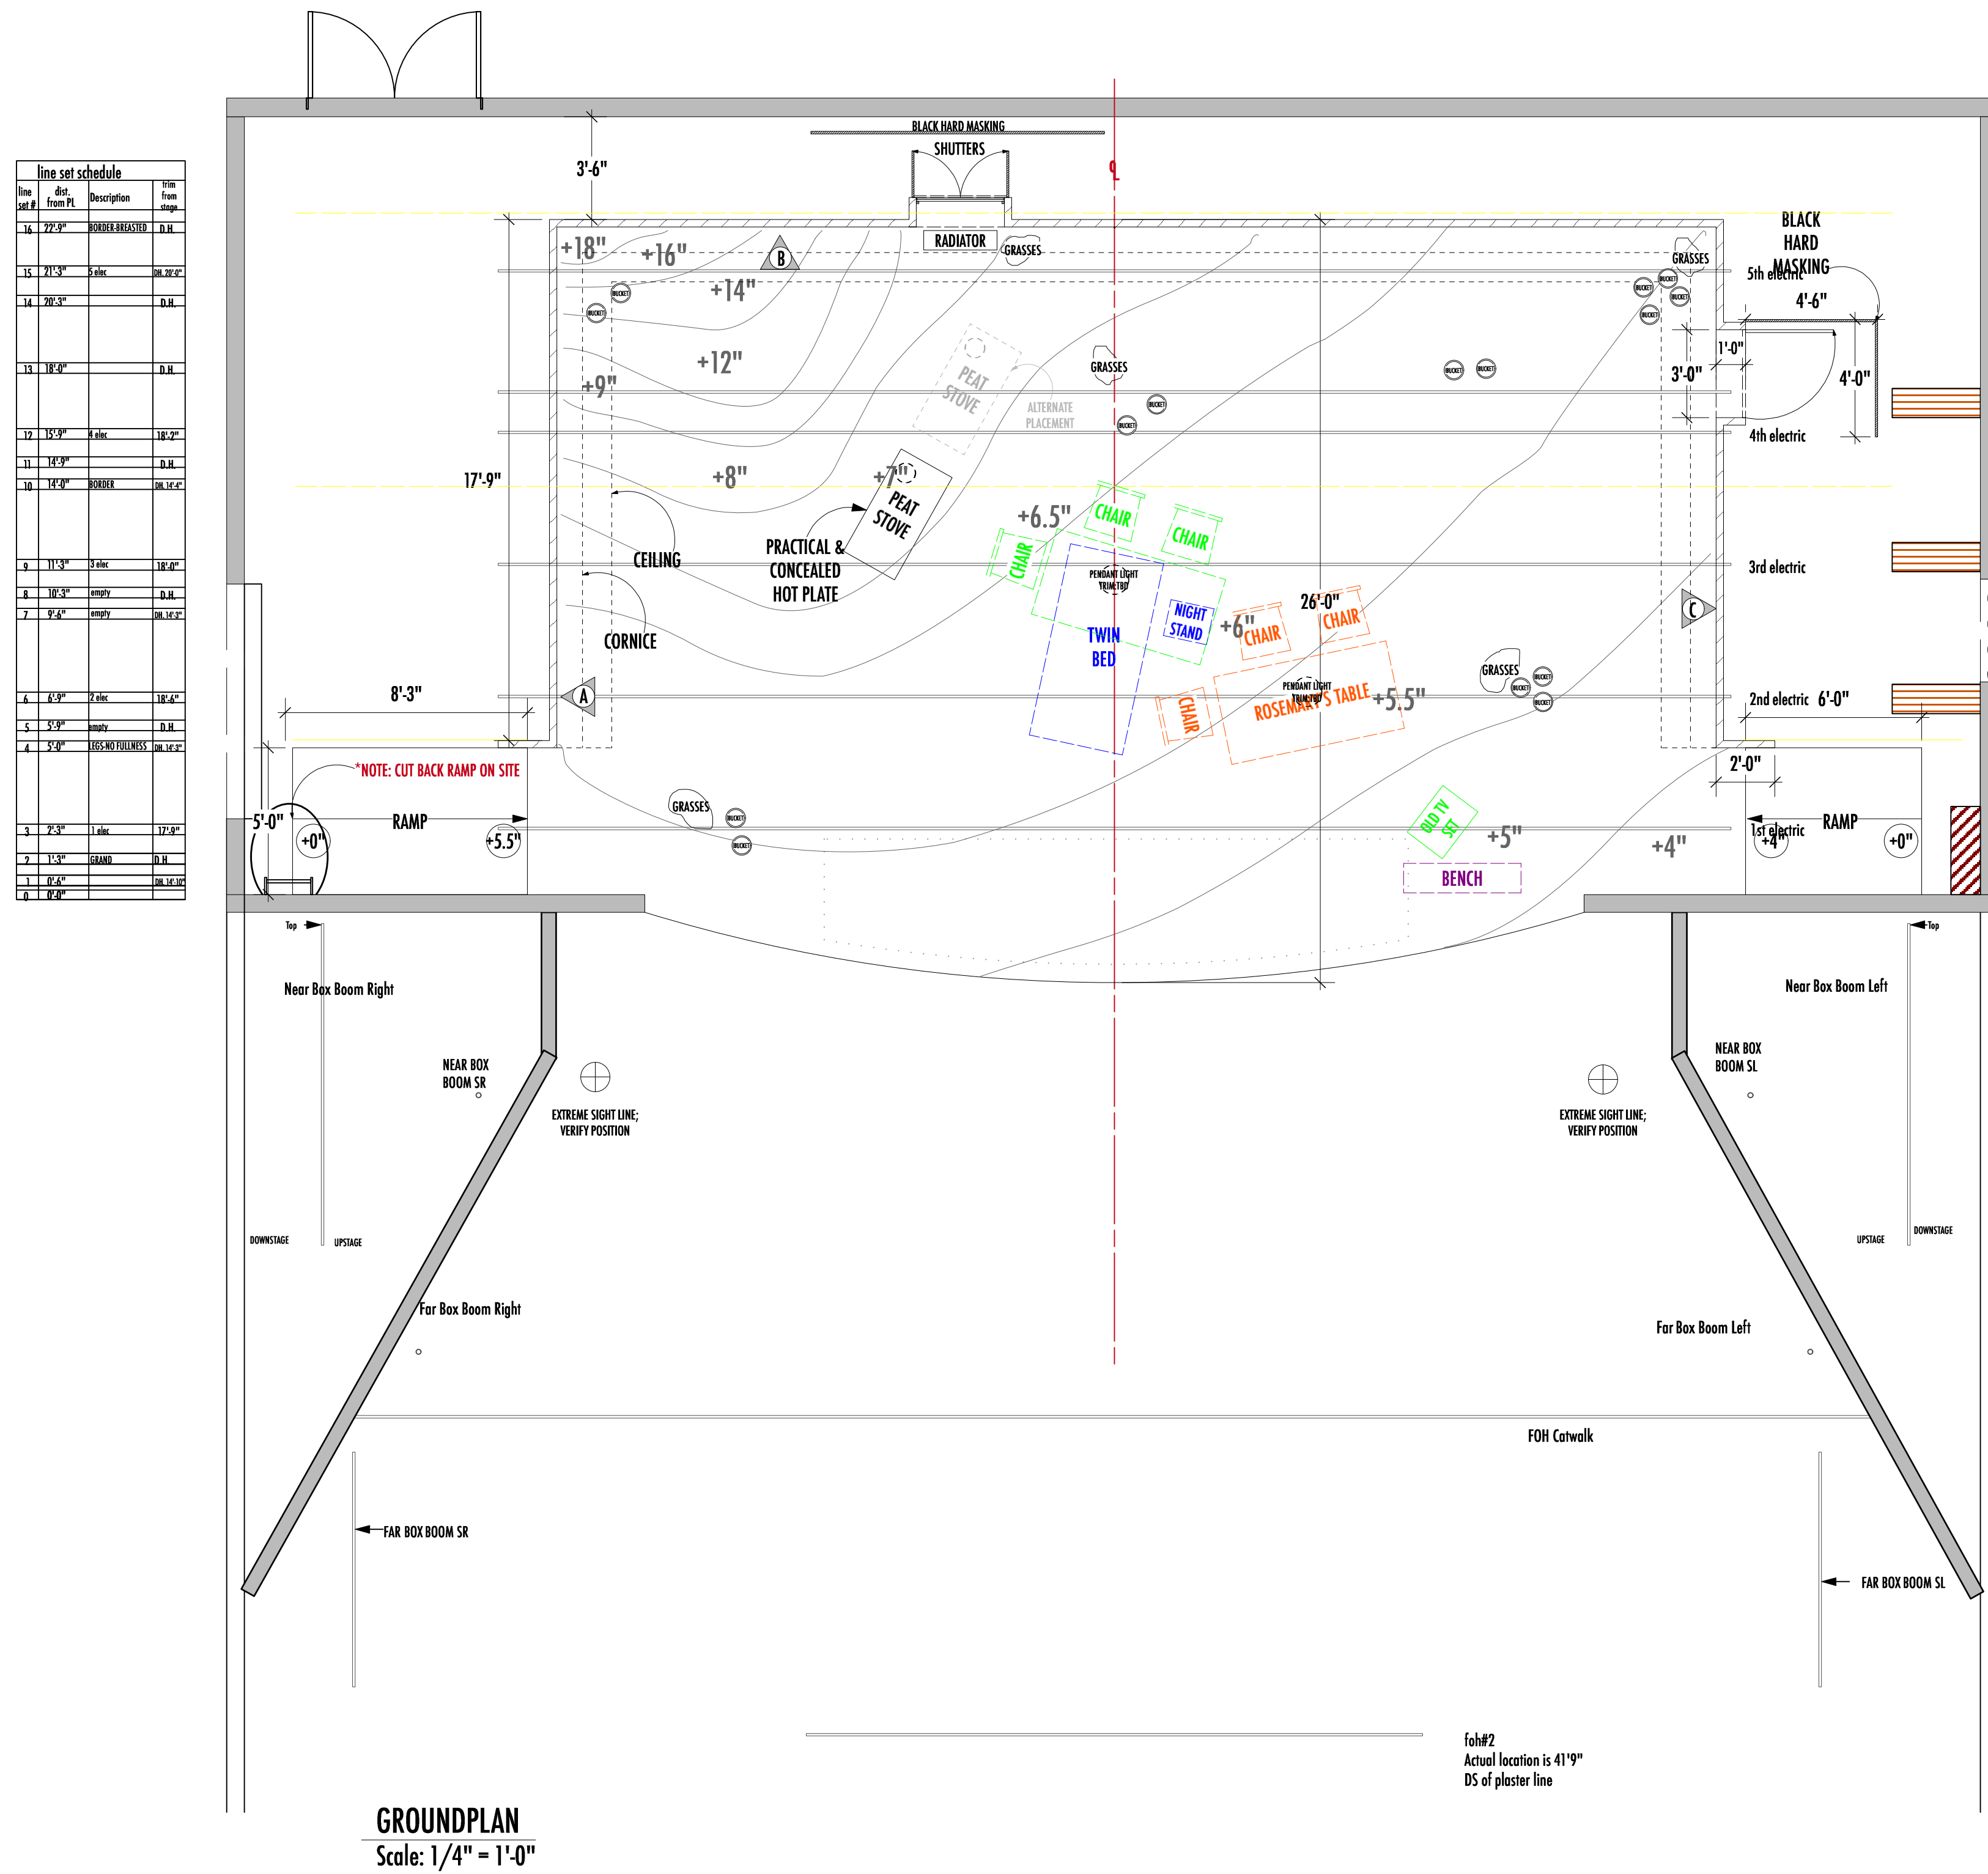


NOTES:

- *THERE IS A DRIP ABOVE ALL OF THE FIFTEEN BUCKETS ON STAGE. THE DRIPS ARE LOW IMPACT AND ALL DRIPPING AT THE SAME TIME.
- *PEAT STOVE NEEDS A HOT PLATE FOR HEATING UP TEA KETTLE. HOT PLATE IS CONCEALED.
- *THERE IS A 1'-0" CEILING OVERHANG AROUND THE WALLS OF THE SET.
- *THERE ARE TWO CEILING LIGHTS IN THE SET. ONE OVER EACH KITCHEN TABLE.
- *BLACK MASKING FLATS ARE COVERED IN BLACK DUVETINE.
- *UPSTAGE MOST BLACK BORDER IS BREASTED BACK AND ATTACHED TO THE UPSTAGE SIDE OF THE WALL.
- *BORDER ON LINESET #10 SITS IN FRONT OF THE STOVE PIPE SO THAT THE PIPE MAY VANISH BEHIND MASKING.



917.570.5105
NARELLE@EARTHLINK.NET

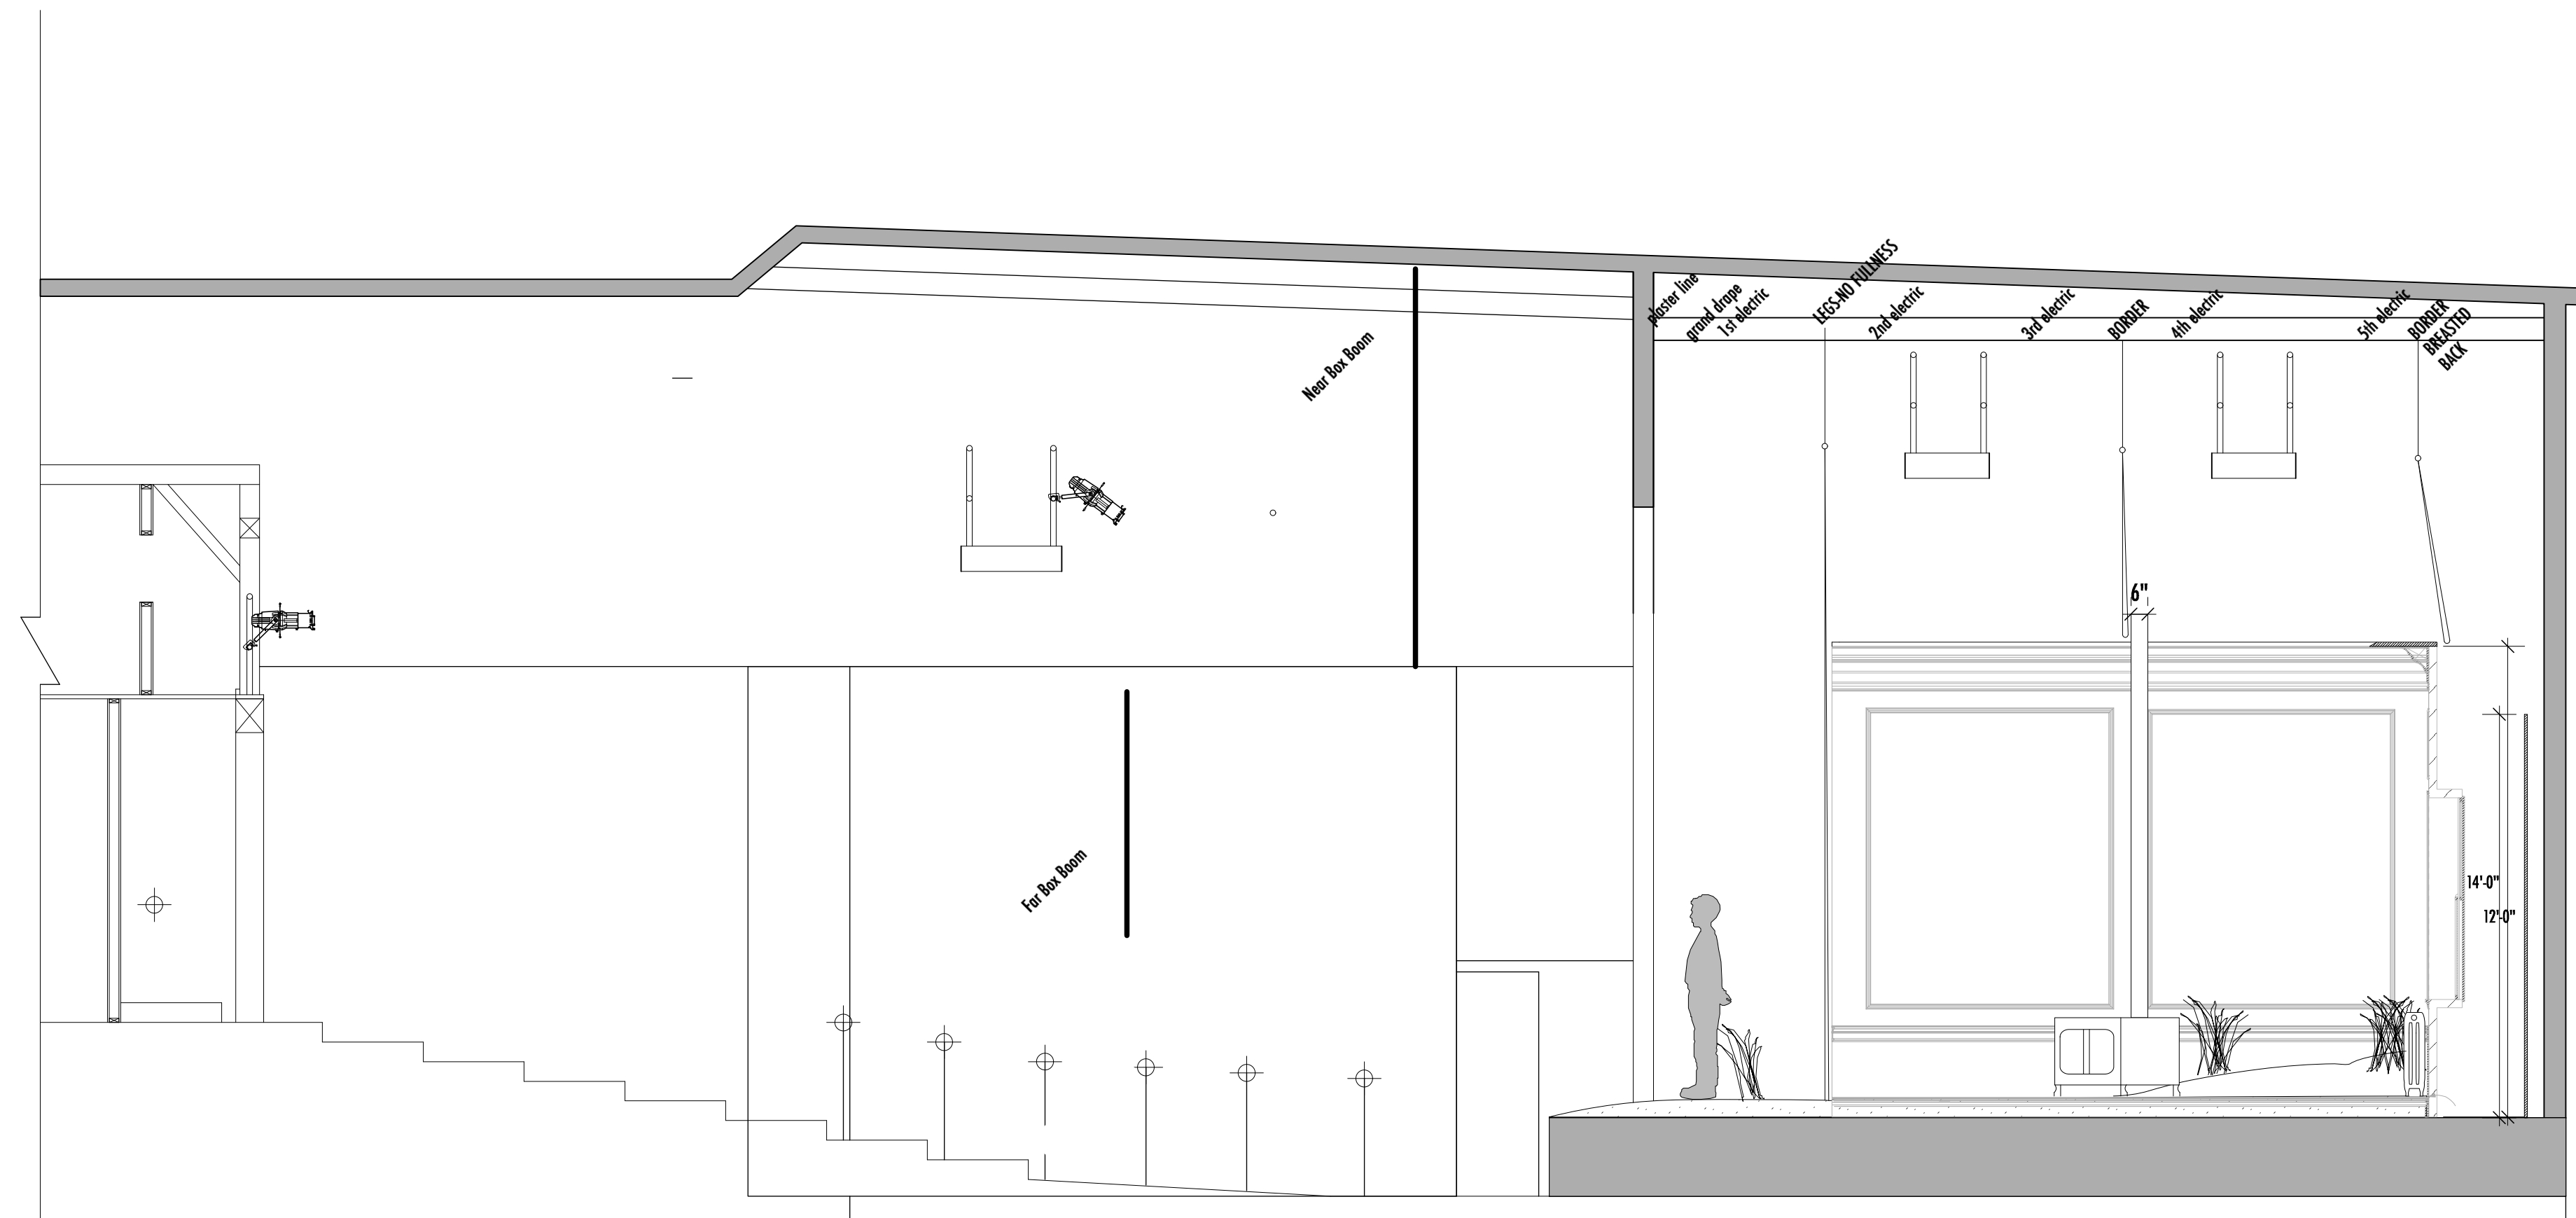

CENTER LINE SECTION-FACING SR
Scale: 1/4" = 1'-0"

OUTSIDE MULLINGAR
BY: JOHN PATRICK SHANLEY
DIRECTED BY: JOHN RUBIN

PRODUCTION TEAM

- SCENIC DESIGNER
NARELLE SISSONS
- LIGHTING DESIGNER
MICHAEL GIANNITTI
- COSTUME DESIGNER
BARBARA BELL
- SOUND DESIGNER
RYAN RUMERY
- MEDIA DESIGNER
KEVIN RAMSER
- TECHNICAL DIRECTOR
KEVIN JOSEPH
- DRAFTINGS BY
JOEY SARNO

The designer is responsible for the visual aspects of the production only, and the specification of the designer's designs relate solely to the appearance of the design and not to matters of safety. The designer agrees to make prompt correcting alterations to any specifications found to be incompatible with proper safety precautions

DORSET THEATRE FESTIVAL

DATE: 04-21-2015

SCALE: 0'-1/4" = 1'-0"

REVISION #1: 05-01-2015

REVISION #2: 05-15-2015

REVISION #3: 05-25-2015

CENTER LINE SECTION

PLATE NO.

2



917.570.5105
NARELLE@EARTHLINK.NET

OUTSIDE MULLINGAR
BY: JOHN PATRICK SHANLEY
DIRECTED BY: JOHN RUBIN

PRODUCTION TEAM

SCENIC DESIGNER	NARELLE SISSONS
LIGHTING DESIGNER	MICHAEL GIANNITTI
COSTUME DESIGNER	BARBARA BELL
SOUND DESIGNER	RYAN RUMERY
MEDIA DESIGNER	KEVIN RAMSER
TECHNICAL DIRECTOR	KEVIN JOSEPH
DRAFTINGS BY	JOEY SARNO

The designer is responsible for the visual aspects of the production only, and the specification of the designer's designs relate solely to the appearance of the design and not to matters of safety. The designer agrees to make prompt correcting alterations to any specifications found to be incompatible with proper safety precautions

DORSET THEATRE FESTIVAL

DATE: 04-21-2015



SCALE: 0'-1/2" = 1'-0"

REVISION #1: 05-01-2015
REVISION #2: 05-15-2015
REVISION #3: 05-25-2015


WALL A ELEVATION

PLATE NO.








3

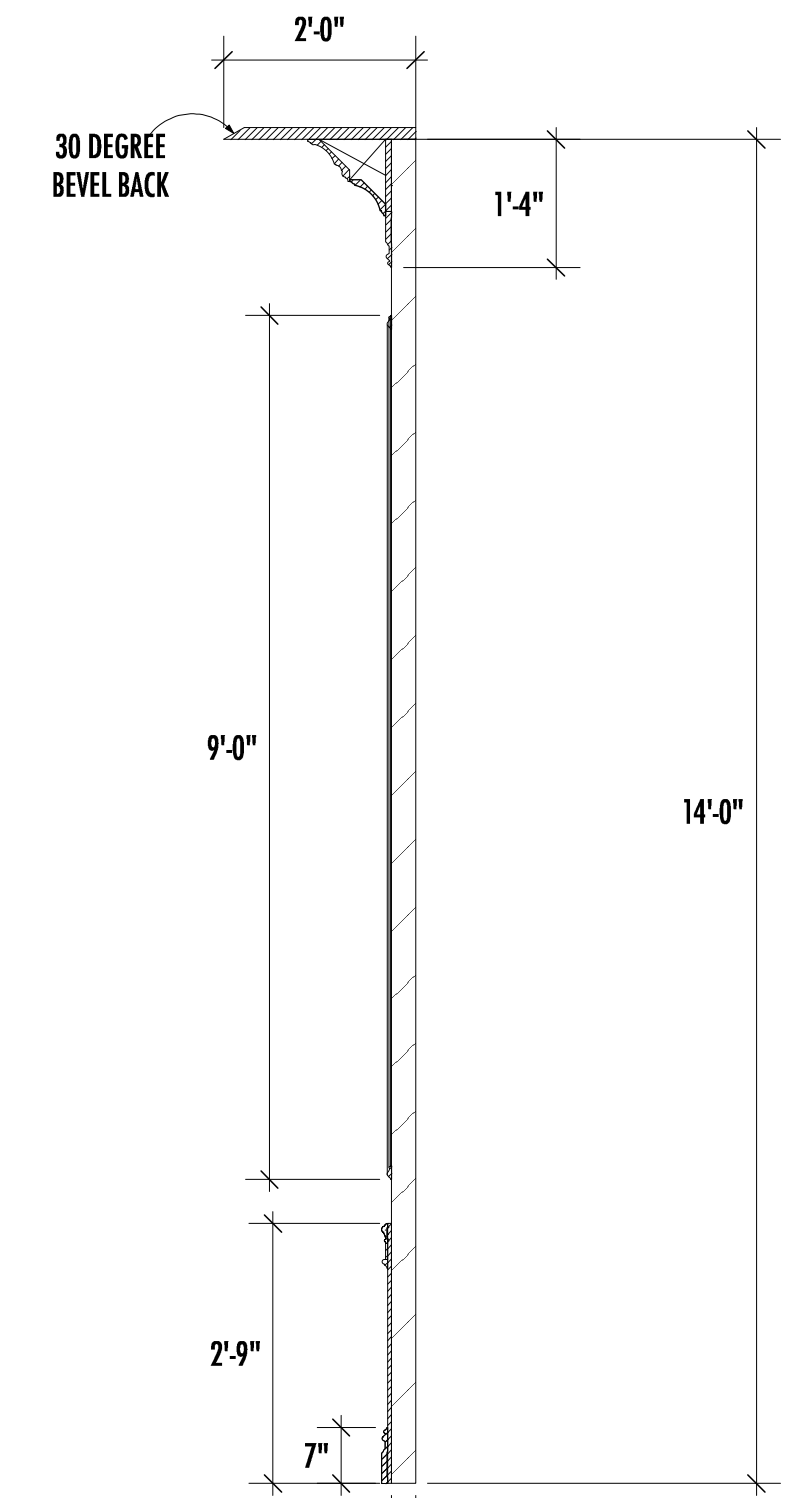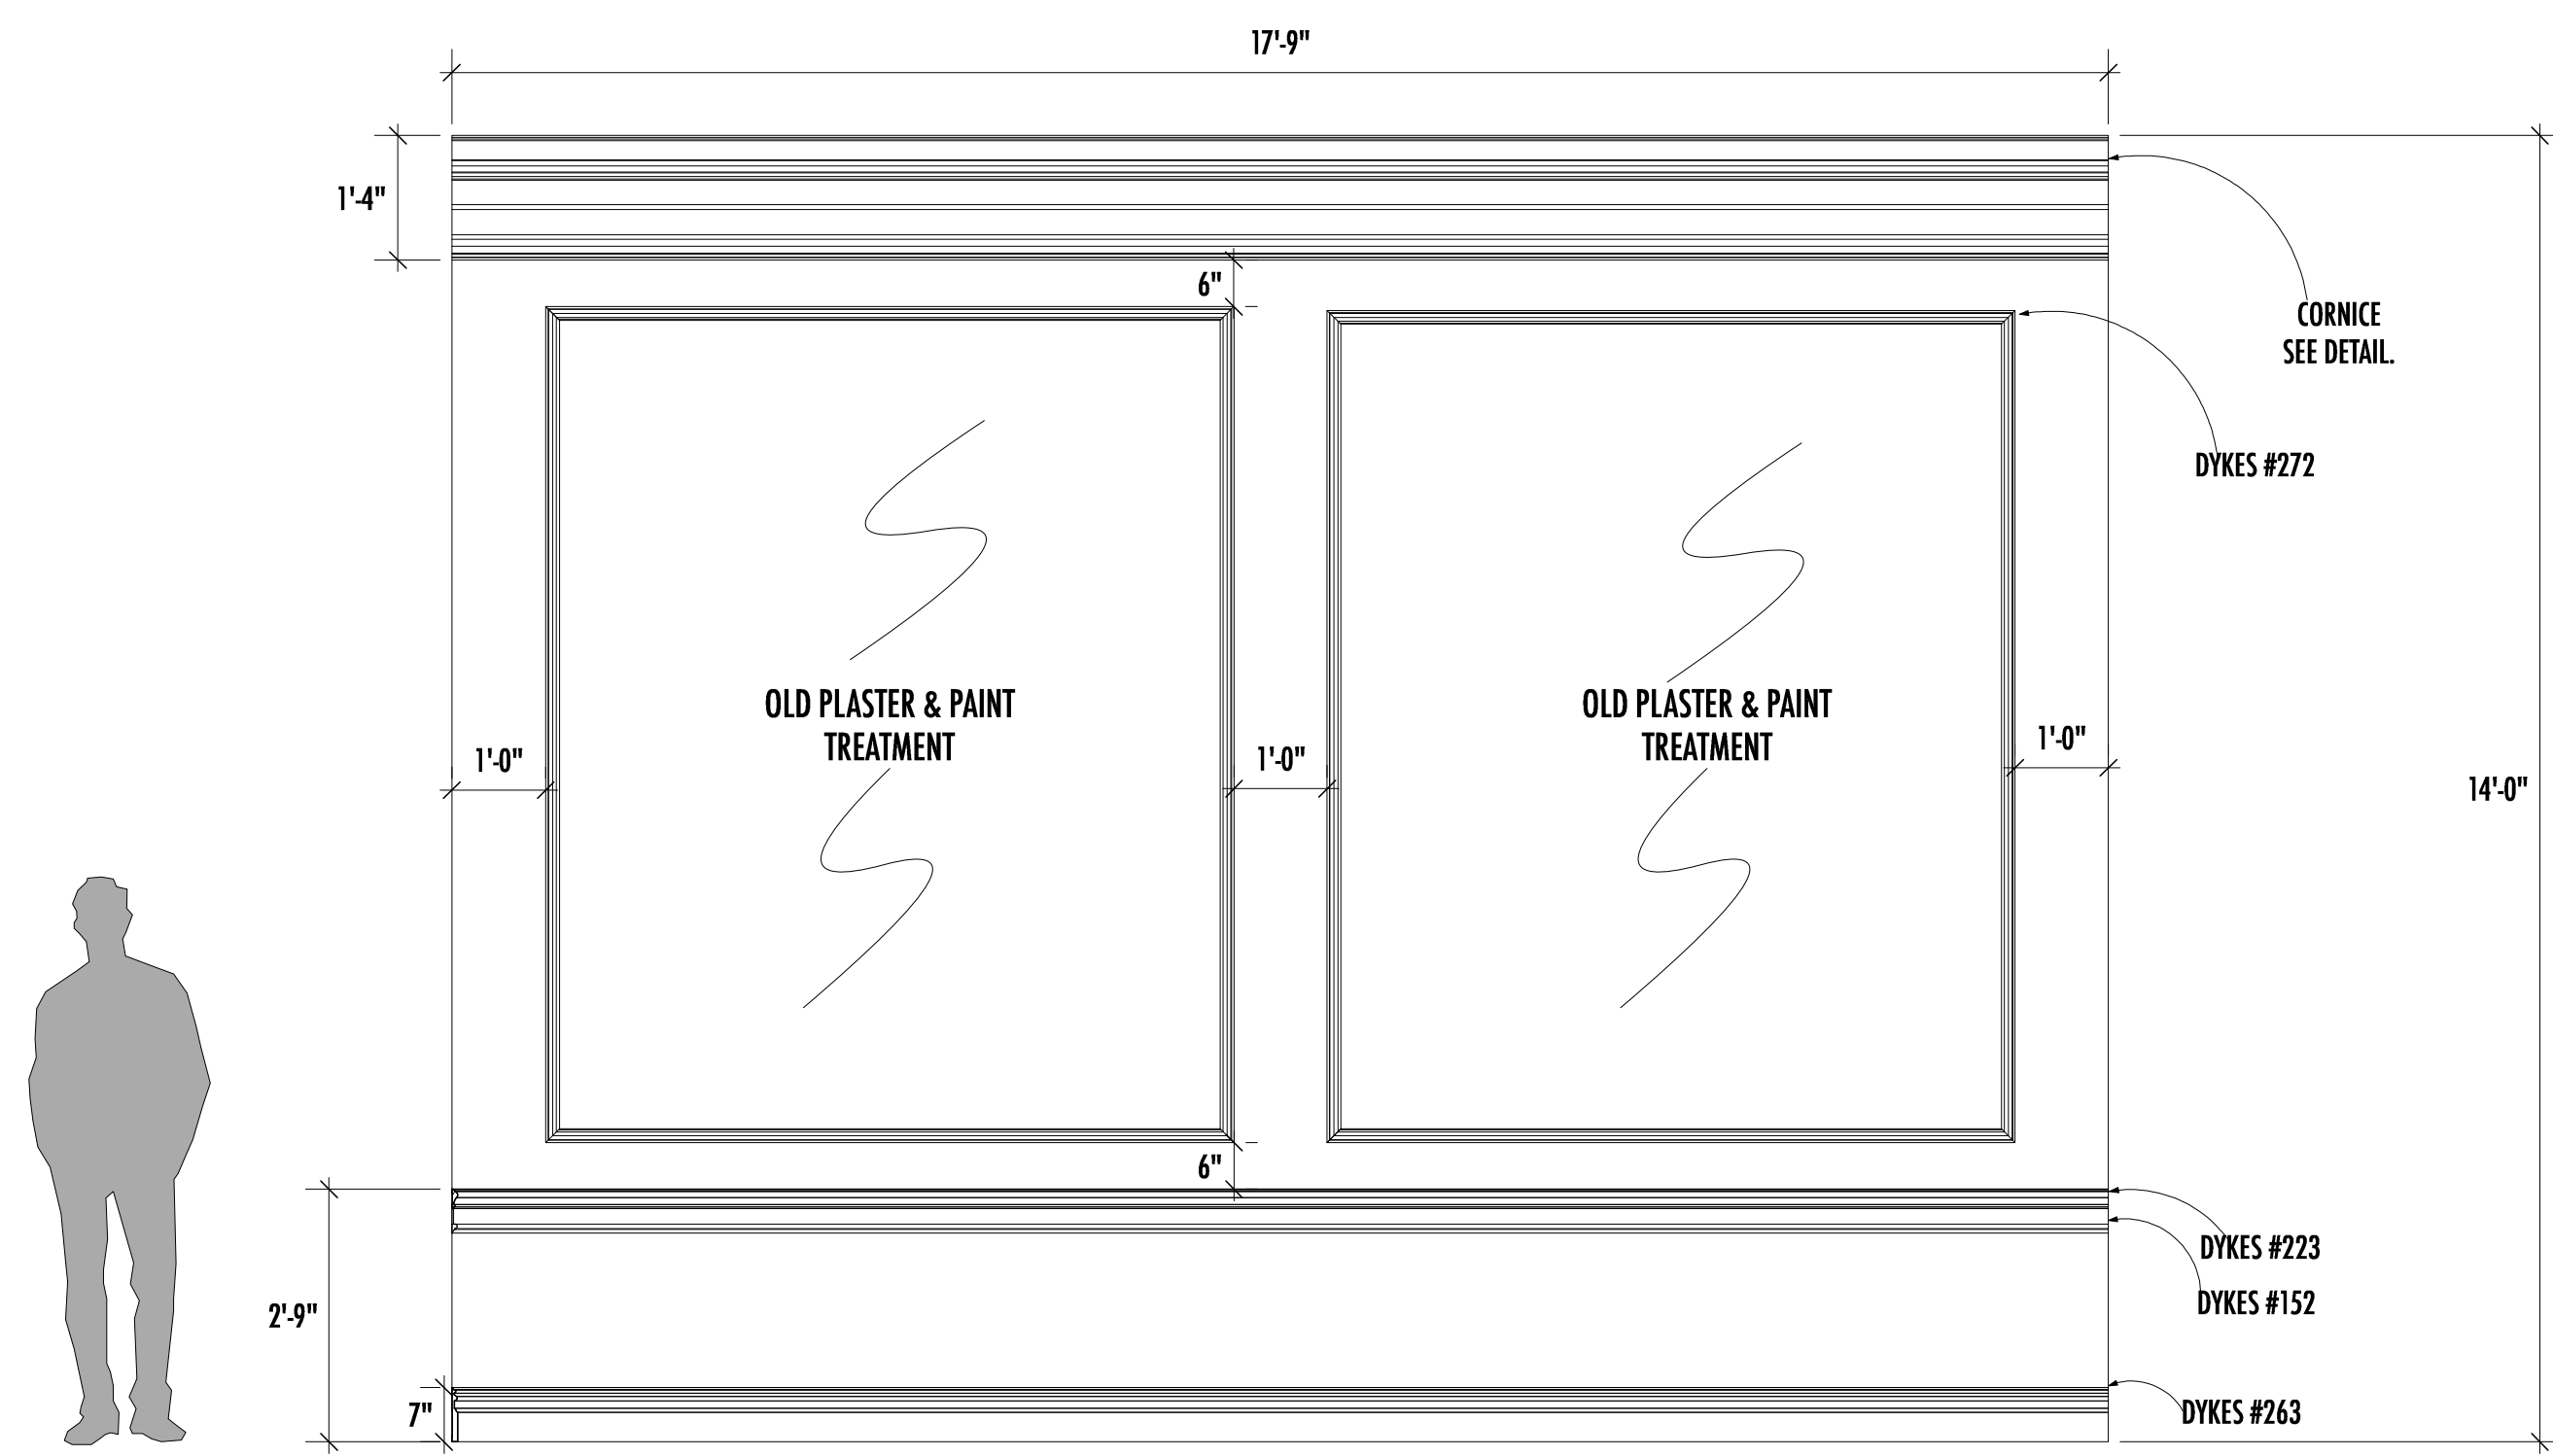


CL SECTION-WALL A
Scale: 1/2" = 1'-0"

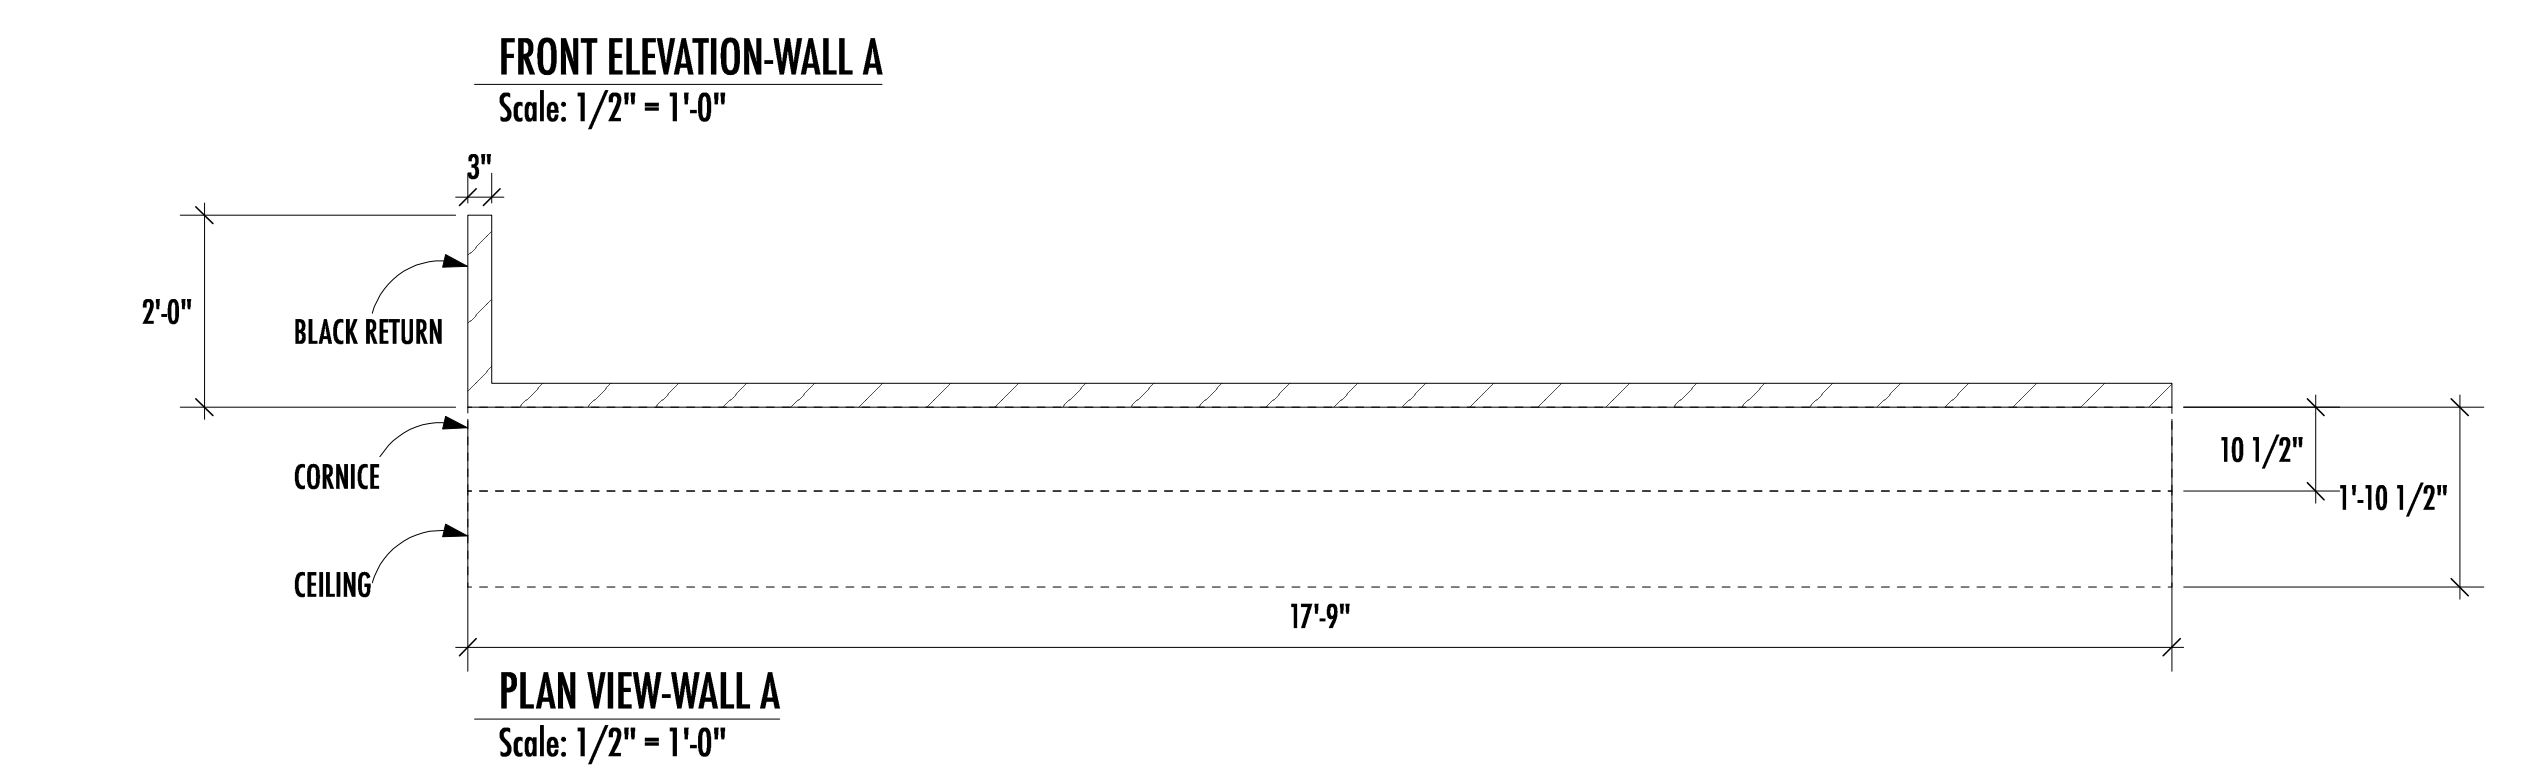


PLAN VIEW-WALL A
Scale: 1/2" = 1'-0"

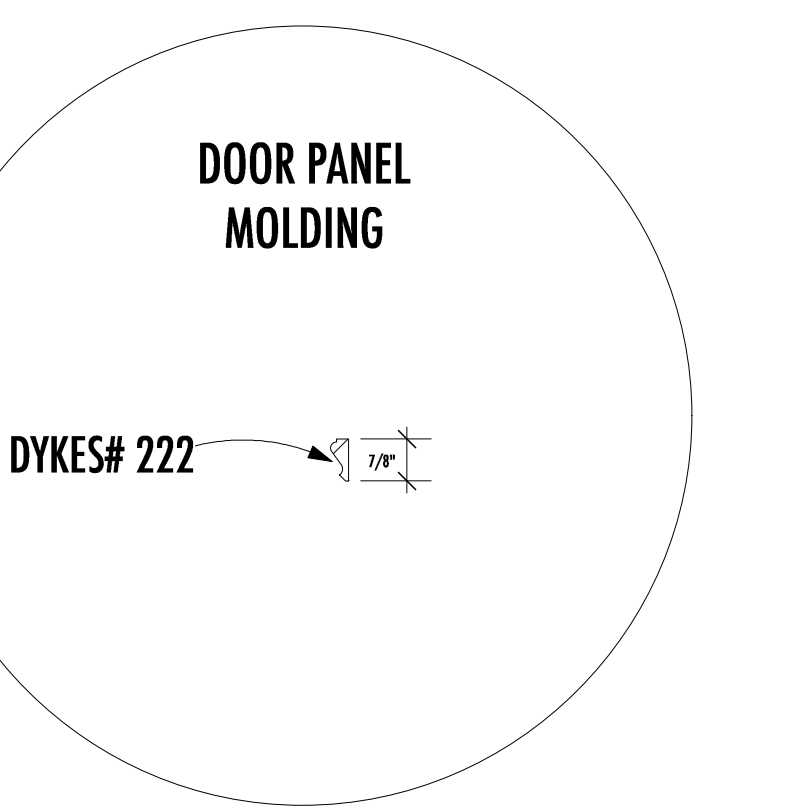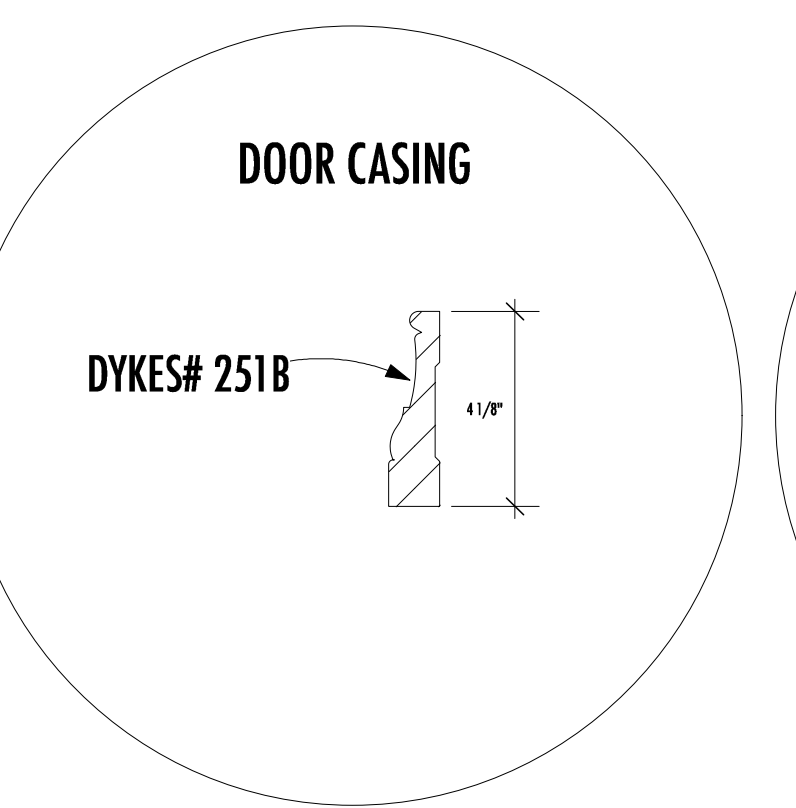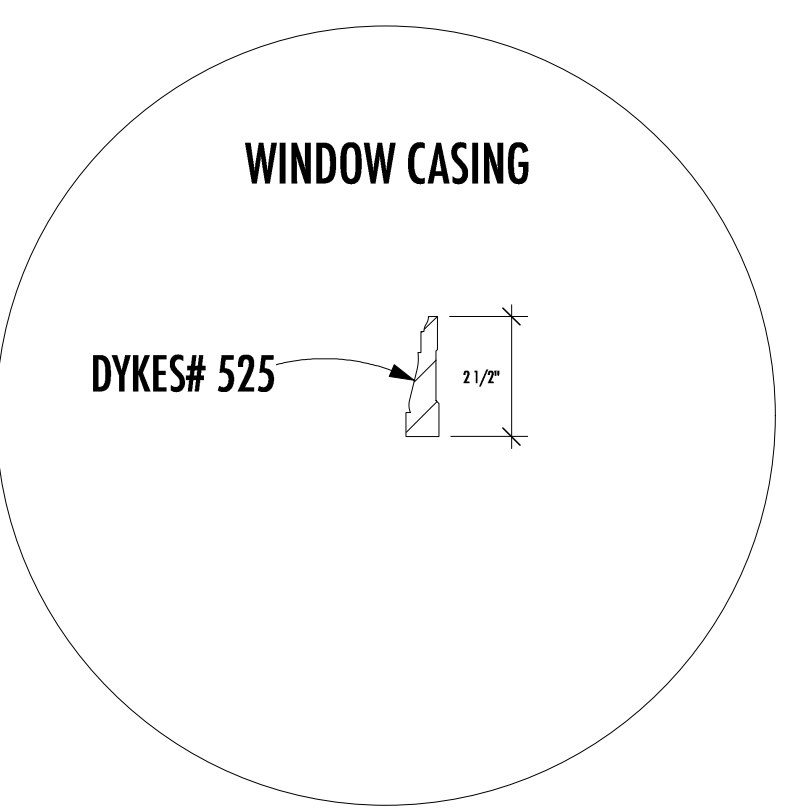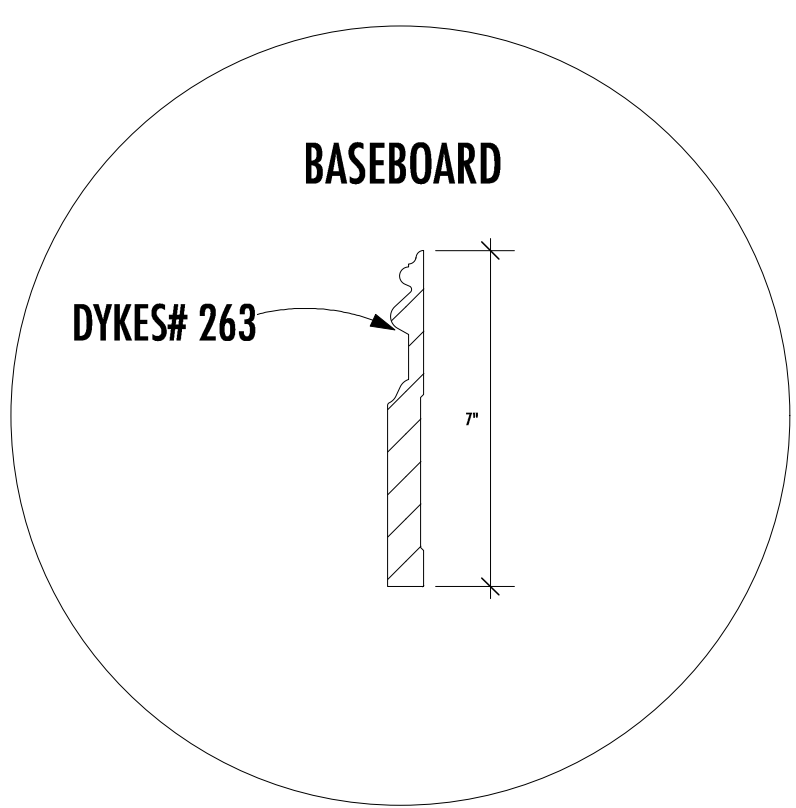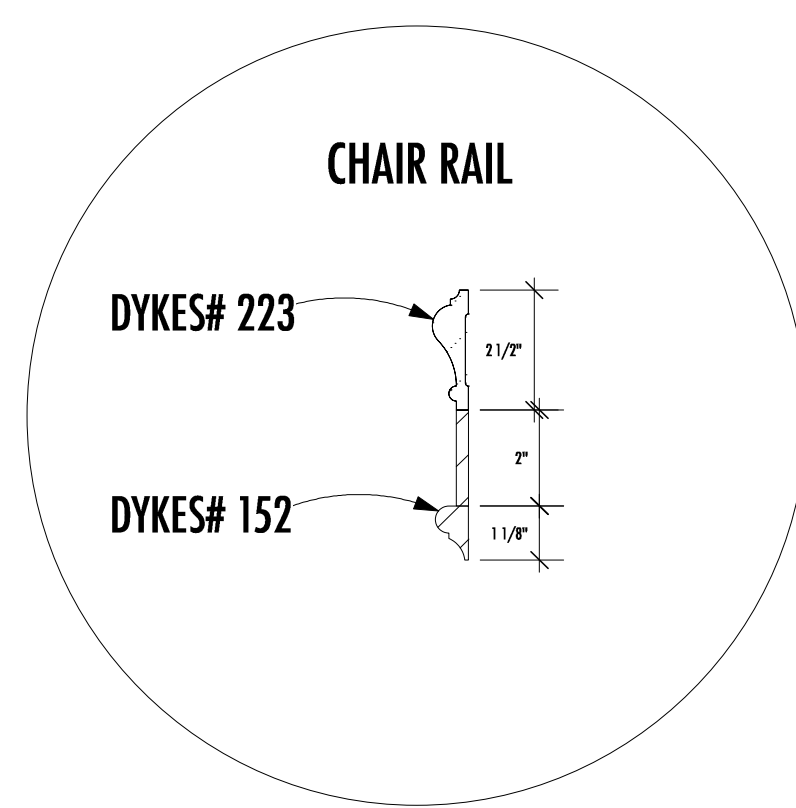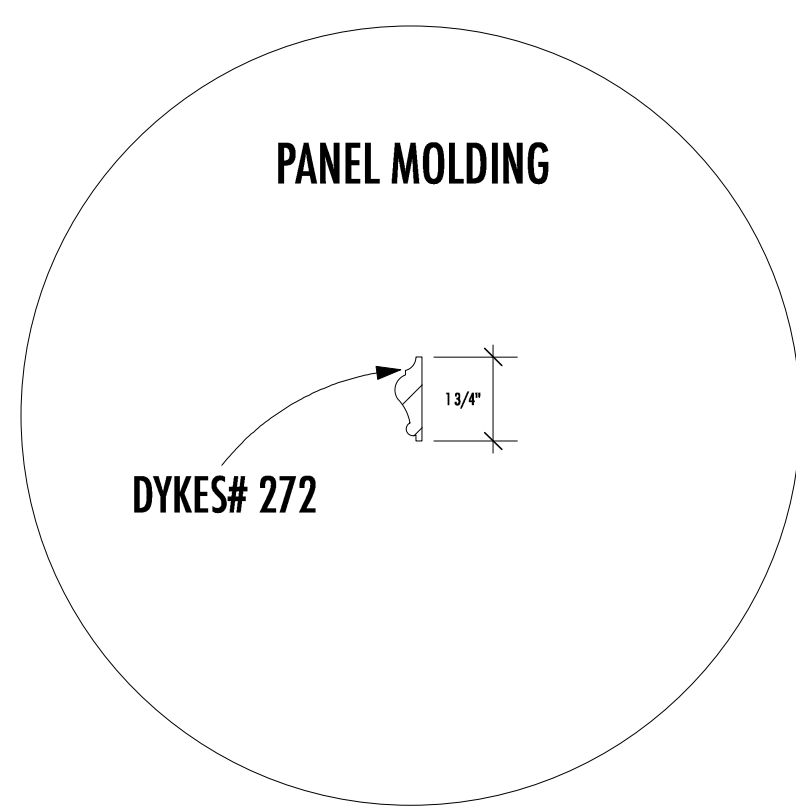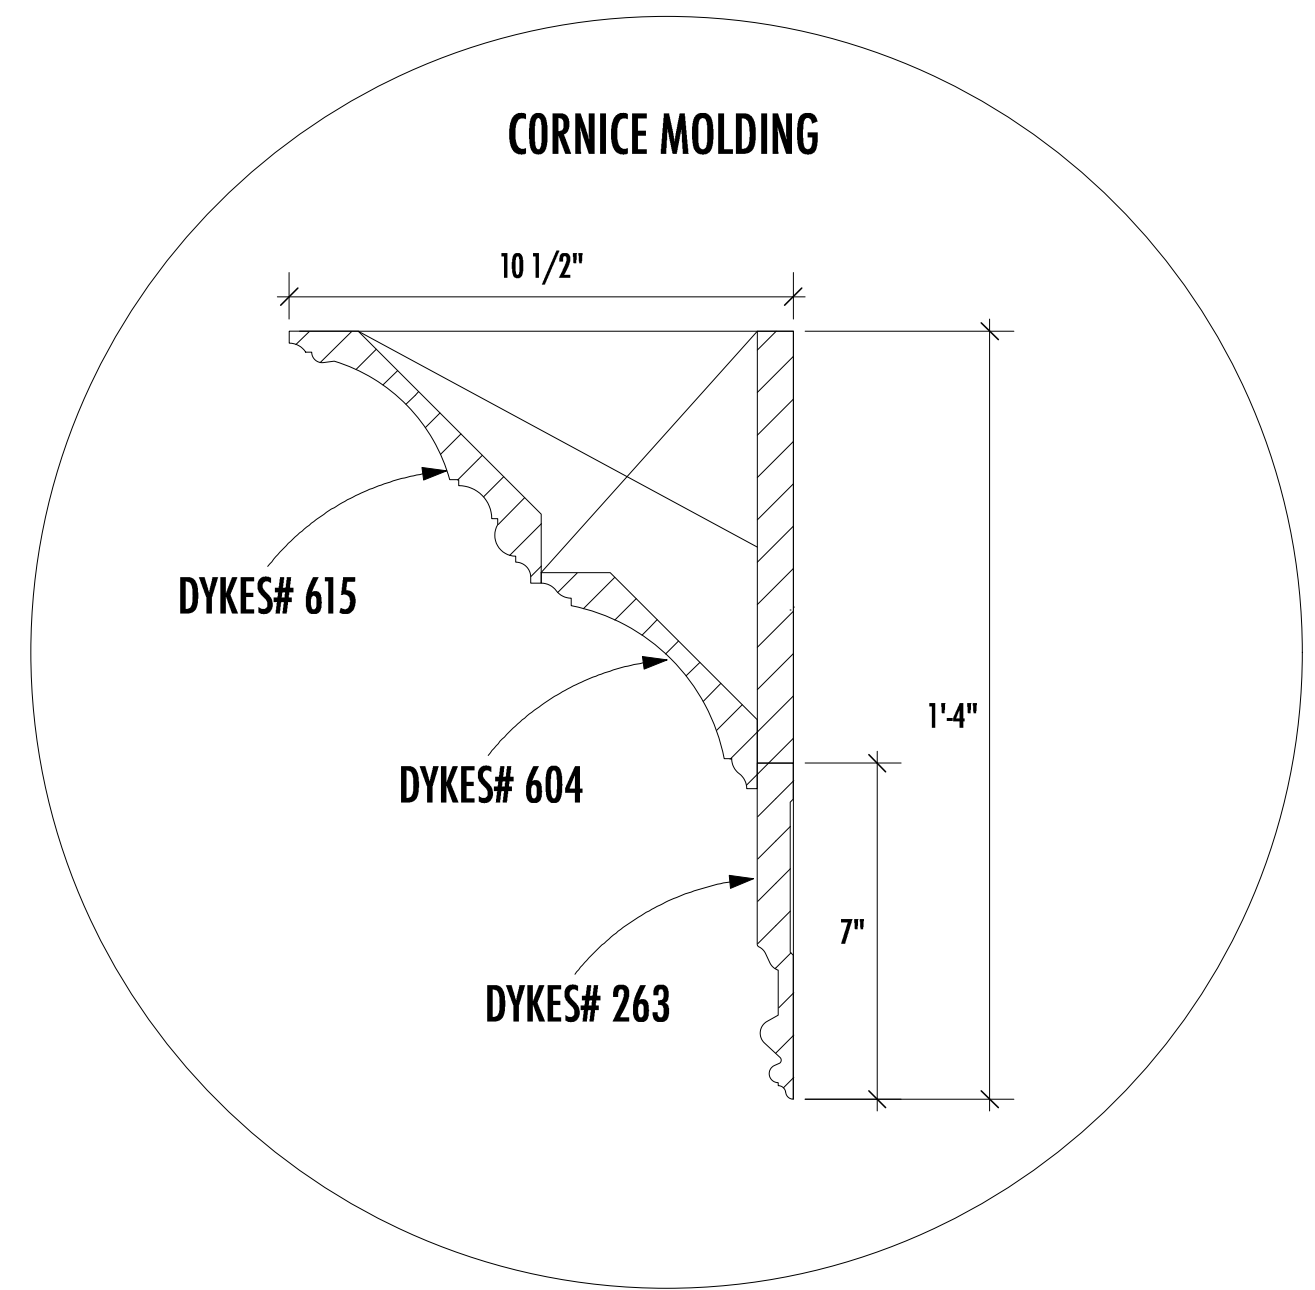


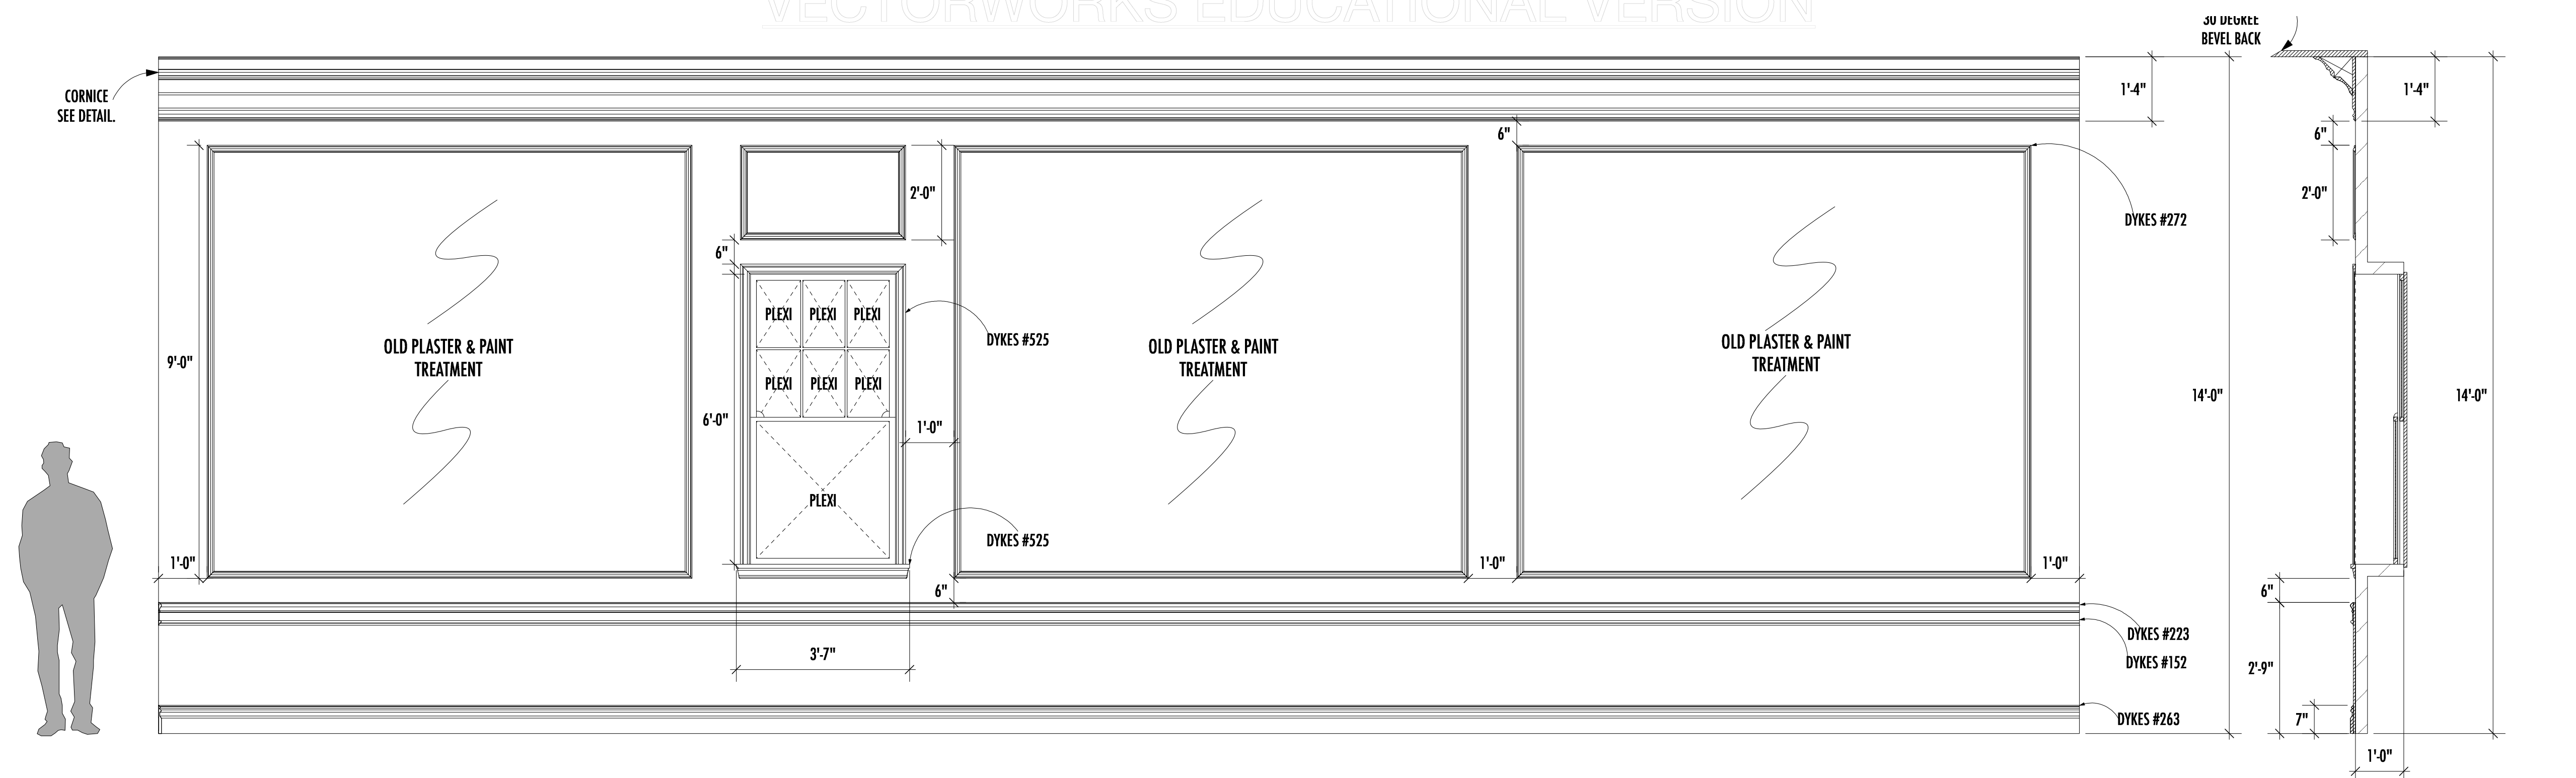


FRONT ELEVATION-WALL B
Scale: 1/2" = 1'-0"

SECTION THROUGH WINDOW-WALL B
Scale: 1/2" = 1'-0"

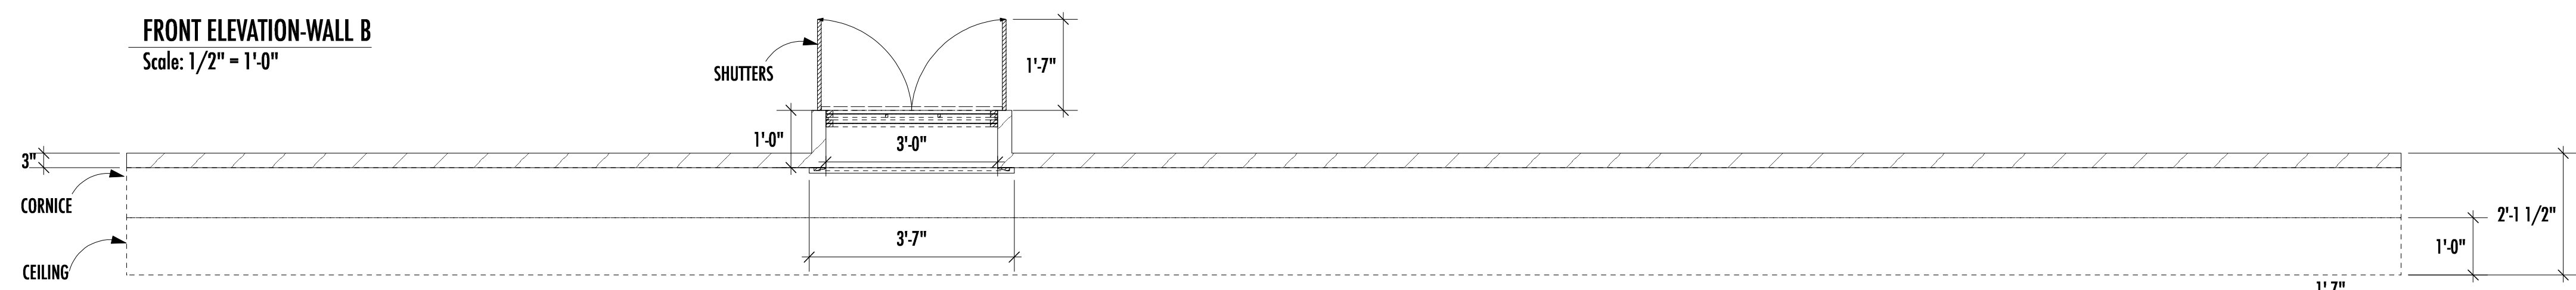


PLAN VIEW-WALL B
Scale: 1/2" = 1'-0"

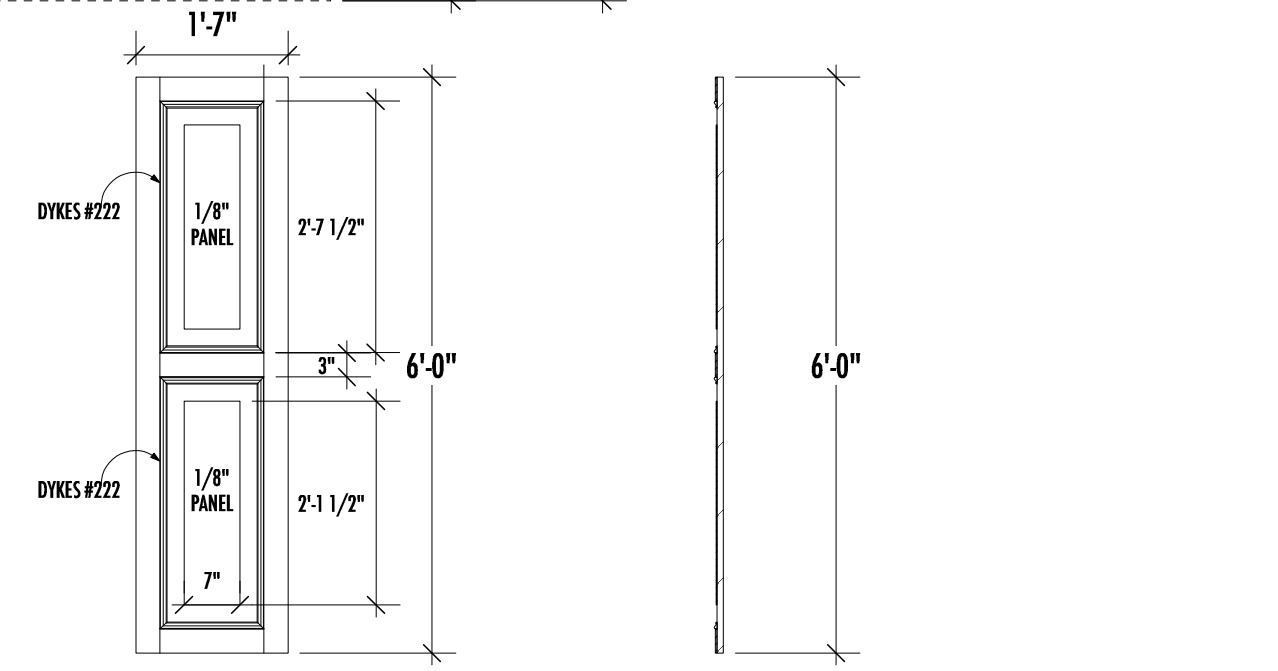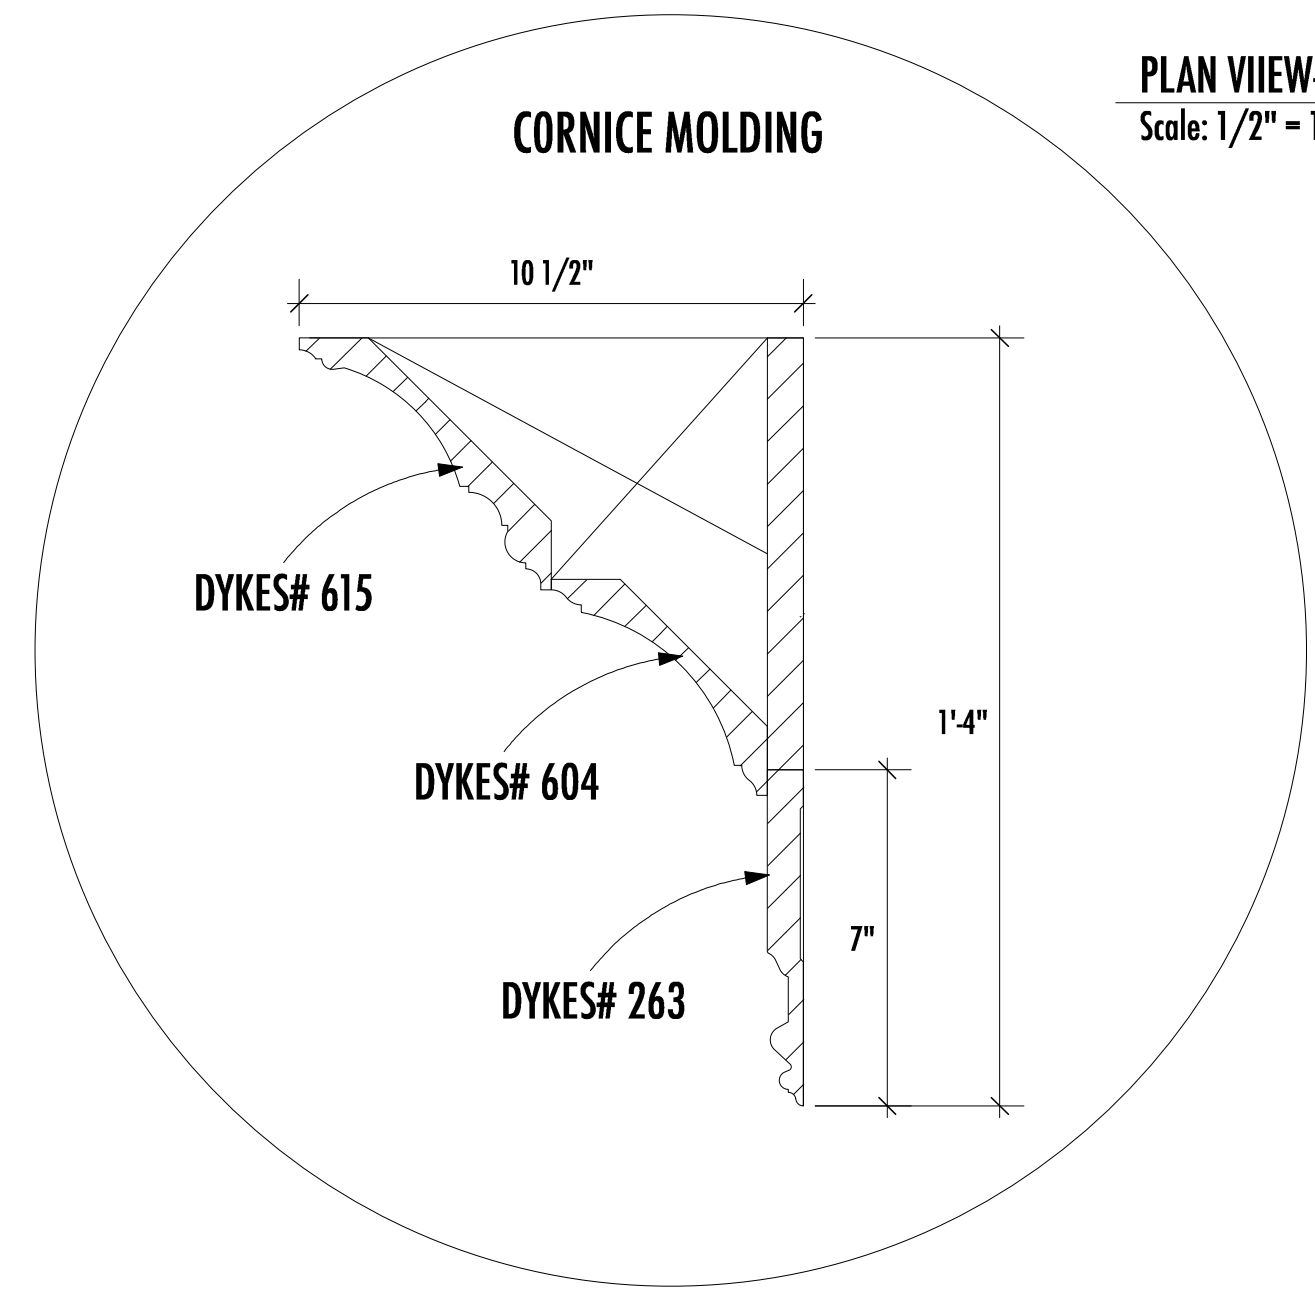

SHUTTER-FRONT ELEVATION
Scale: 1/2" = 1'-0"






SECTION THROUGH SHUTTER
Scale: 1/2" = 1'-0"

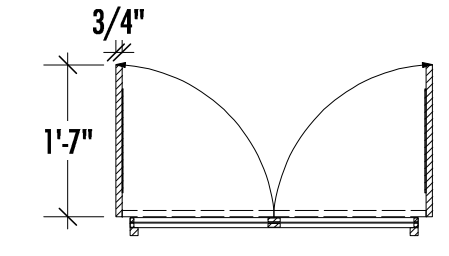

SHUTTER-PLAN VIEW
Scale: 1/2" = 1'-0"

NOTE:
*ADJUST TO FIT AS NECESSARY.
*PANELS ON ONLY ONE SIDE OF SHUTTERS.

BUILD SHUTTER X (2)

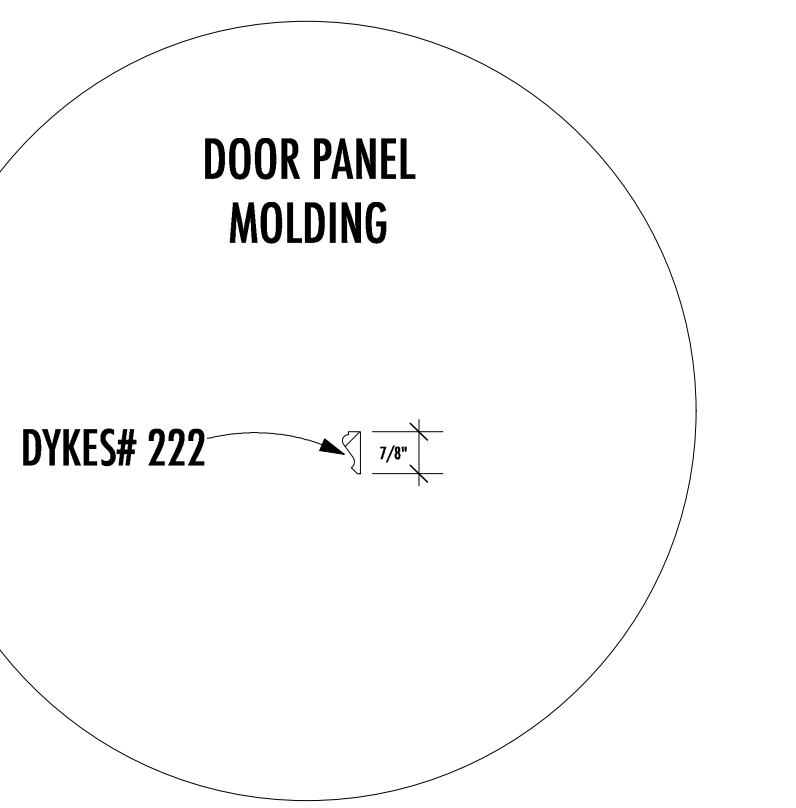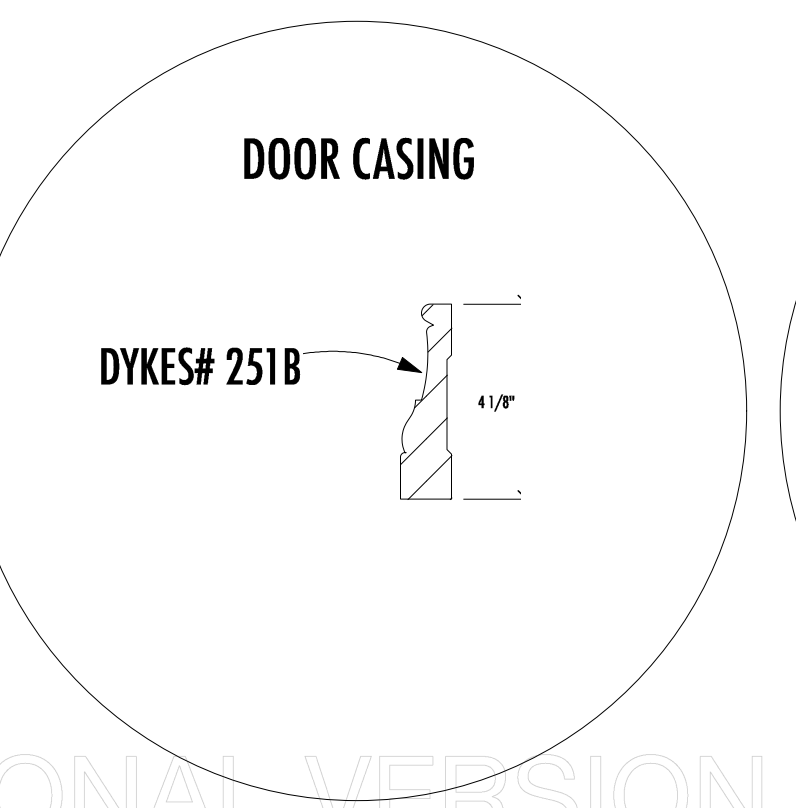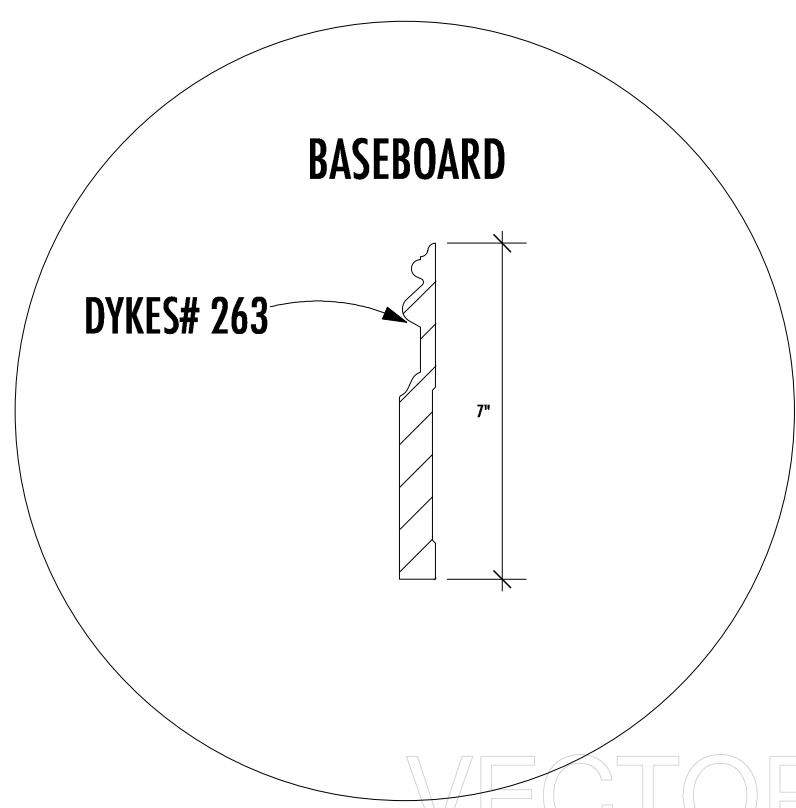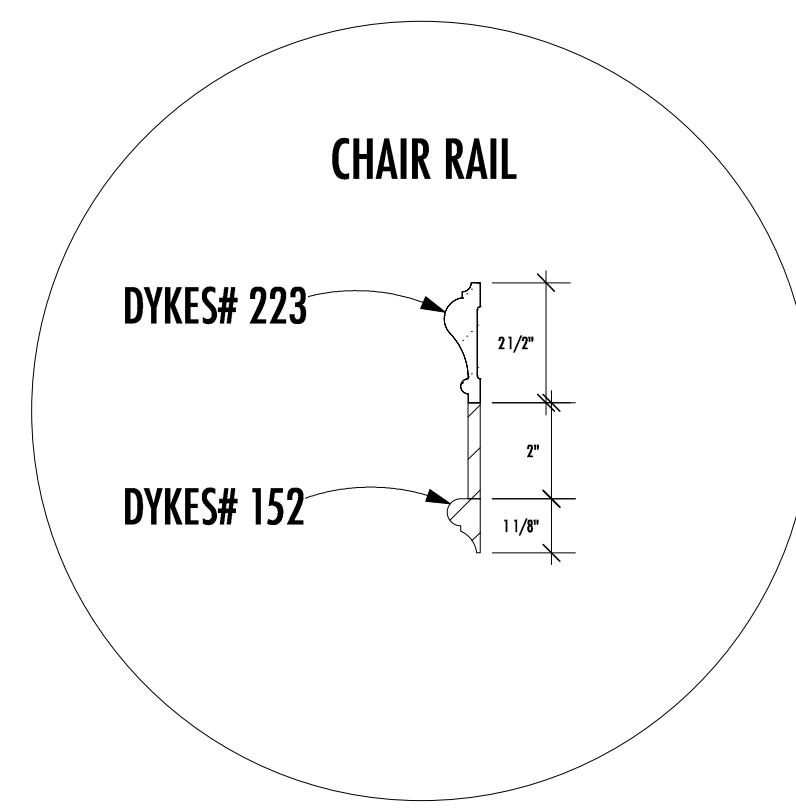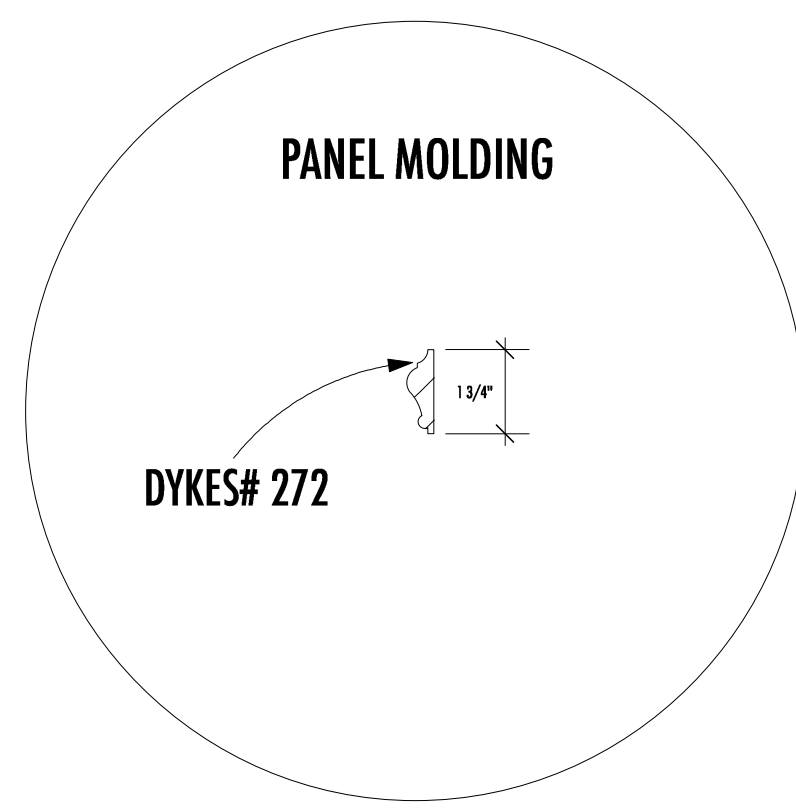

917.570.5105
NARELLE@EARTHLINK.NET

OUTSIDE MULLINGAR

BY: JOHN PATRICK SHANLEY

DIRECTED BY: JOHN RUBIN

PRODUCTION TEAM

- SCENIC DESIGNER
NARELLE SISSONS
- LIGHTING DESIGNER
MICHAEL GIANNITTI
- COSTUME DESIGNER
BARBARA BELL
- SOUND DESIGNER
RYAN RUMERY
- MEDIA DESIGNER
KEVIN RAMSER
- TECHNICAL DIRECTOR
KEVIN JOSEPH
- DRAFTINGS BY
JOEY SARNO

The designer is responsible for the visual aspects of the production only, and the specification of the designer's designs relate solely to the appearance of the design and not to matters of safety. The designer agrees to make prompt correcting alterations to any specifications found to be incompatible with proper safety precautions

DORSET THEATRE FESTIVAL

DATE: 04-21-2015

SCALE: 0'-1/2" = 1'-0"

REVISION #1: 05-01-2015
REVISION #2: 05-15-2015
REVISION #3: 05-25-2015

WALL B ELEVATION

PLATE NO.

4



917.570.5105
NARELLE@EARTHLINK.NET

OUTSIDE MULLINGAR

BY: JOHN PATRICK SHANLEY
DIRECTED BY: JOHN RUBIN

PRODUCTION TEAM

SCENIC DESIGNER	NARELLE SISSONS
LIGHTING DESIGNER	MICHAEL GIANNITTI
COSTUME DESIGNER	BARBARA BELL
SOUND DESIGNER	RYAN RUMERY
MEDIA DESIGNER	KEVIN RAMSER
TECHNICAL DIRECTOR	KEVIN JOSEPH
DRAFTINGS BY	JOEY SARNO

The designer is responsible for the visual aspects of the production only, and the specification of the designer's designs relate solely to the appearance of the design and not to matters of safety. The designer agrees to make prompt correcting alterations to any specifications found to be incompatible with proper safety precautions

DORSET THEATRE FESTIVAL

DATE: 04-21-2015










SCALE: 0'-1/2" = 1'-0"



REVISION #1: 05-01-2015
REVISION #2: 05-15-2015
REVISION #3: 05-25-2015

WALL C ELEVATION

PLATE NO.

5

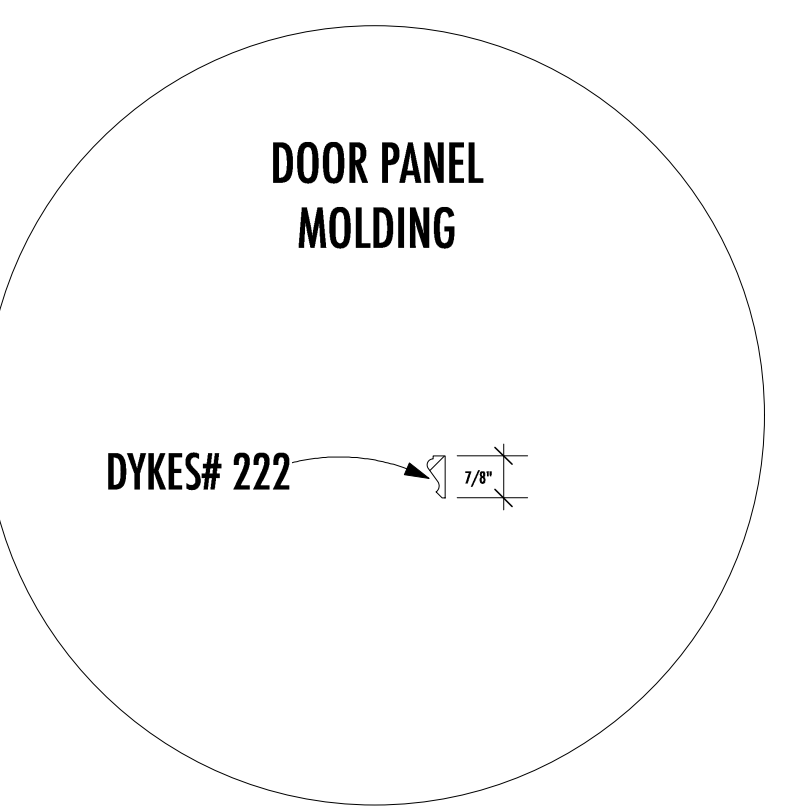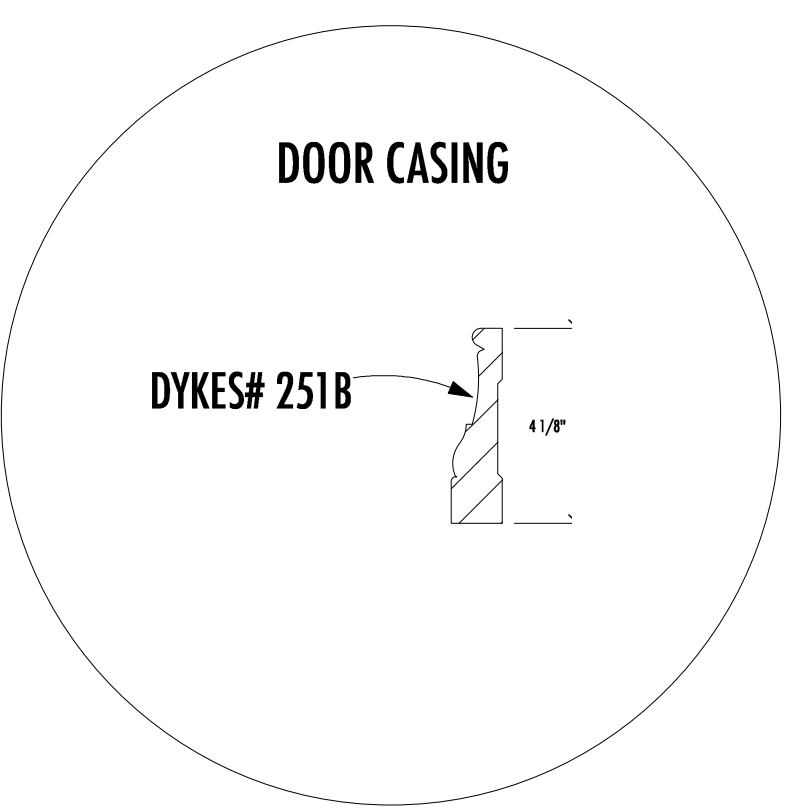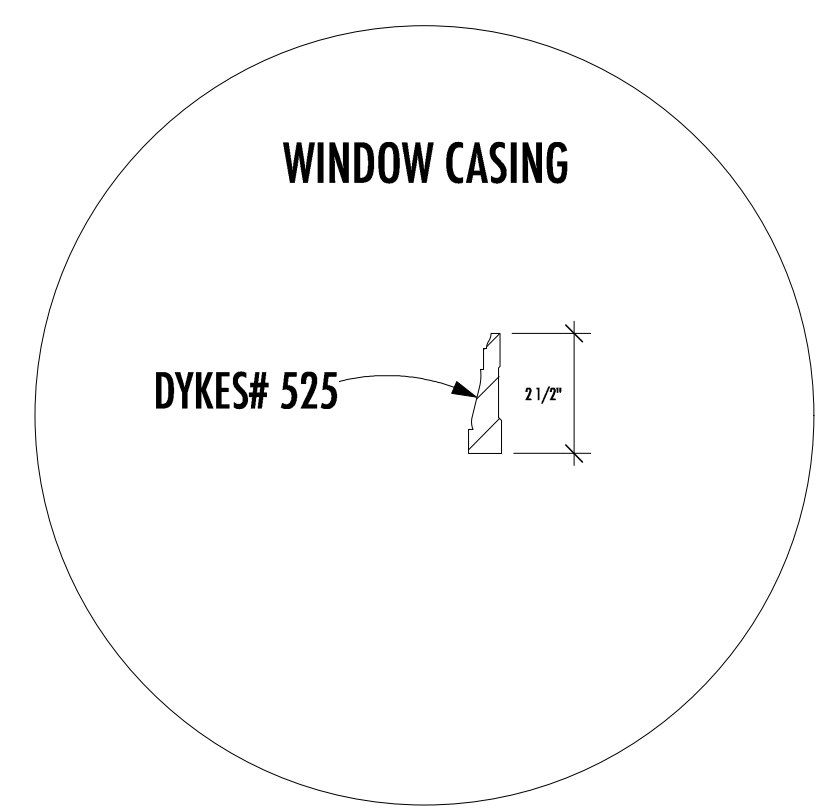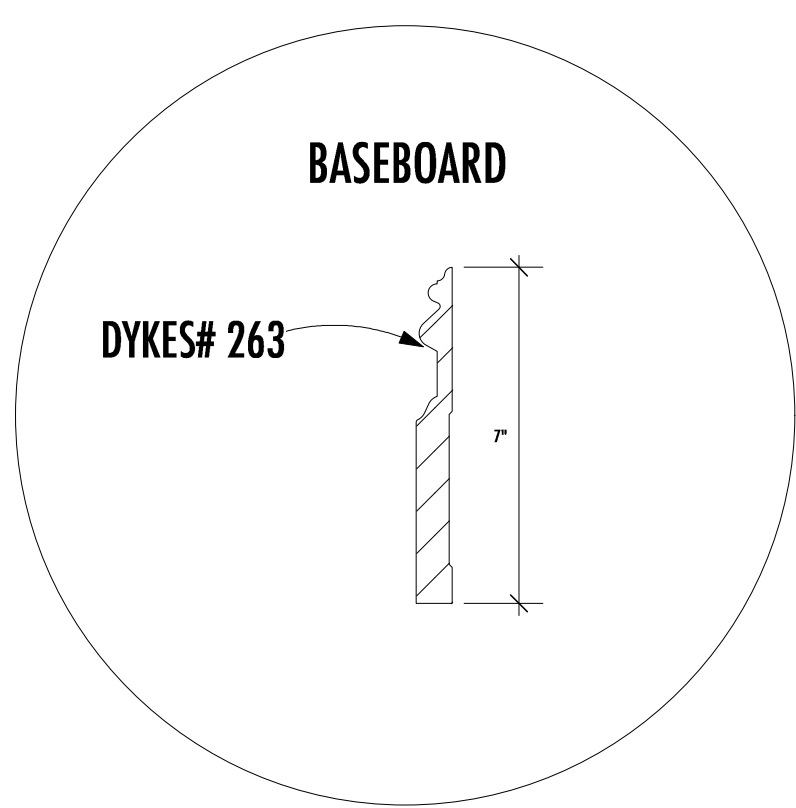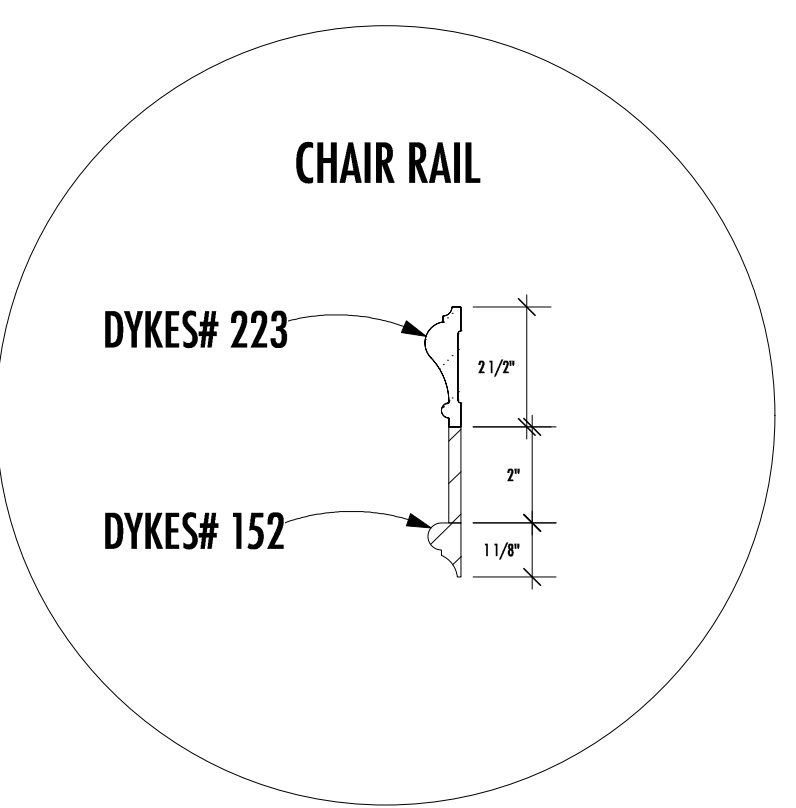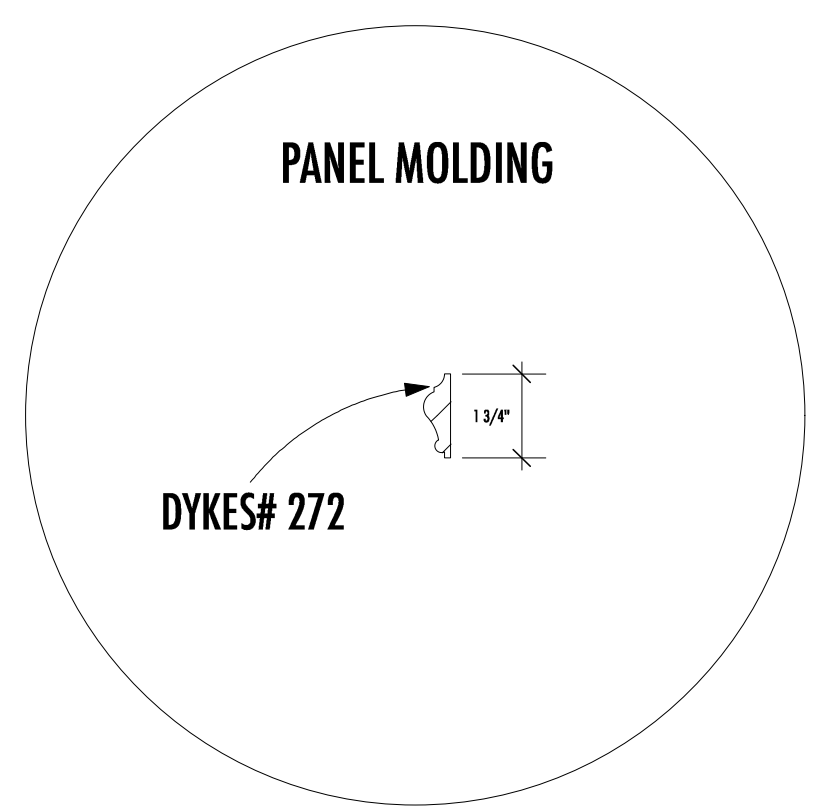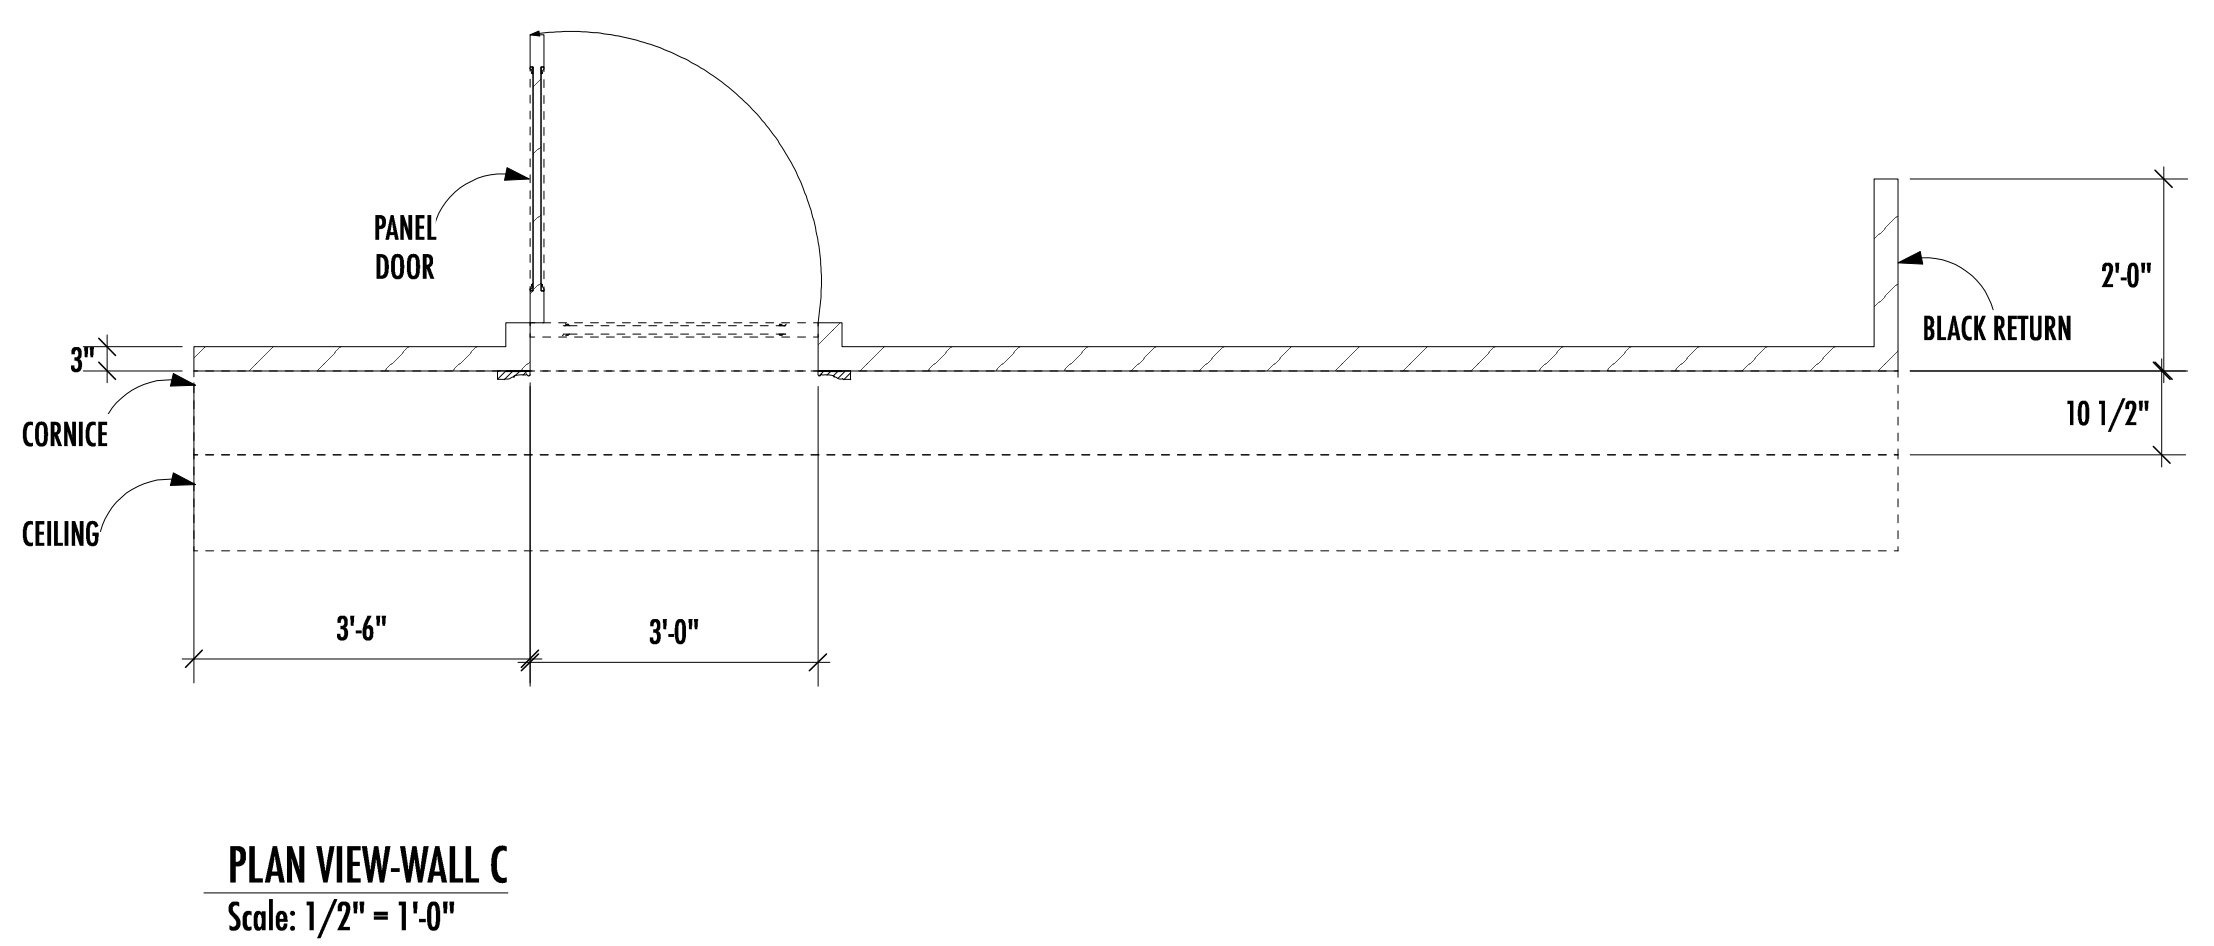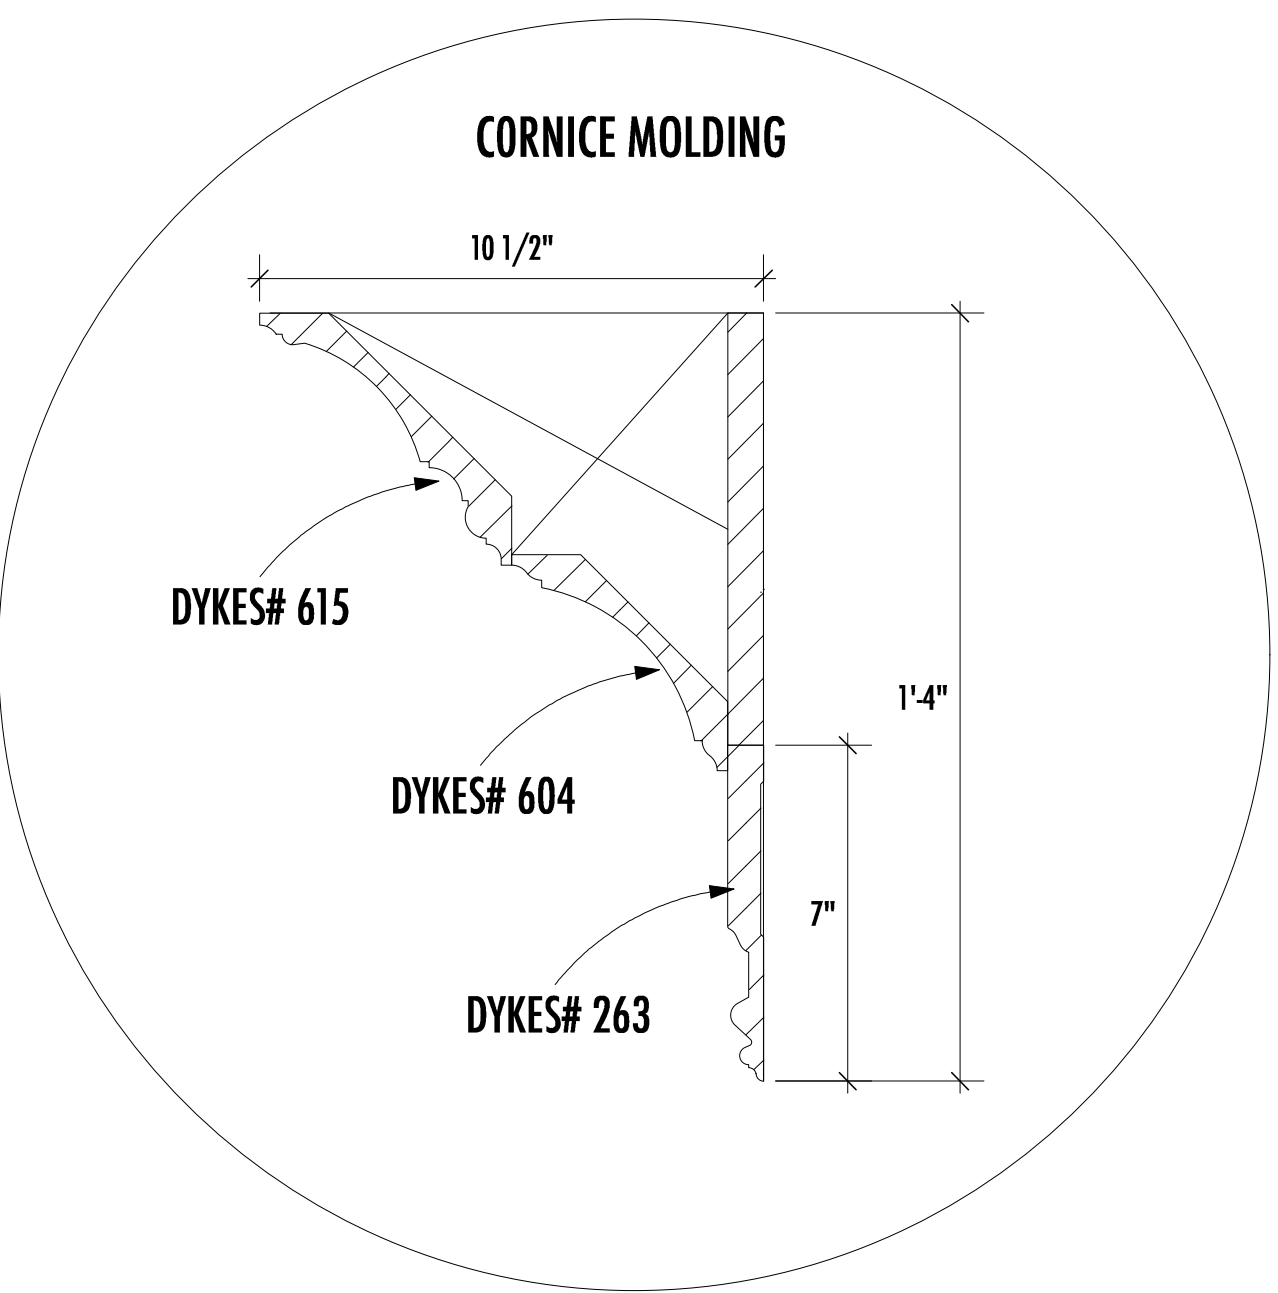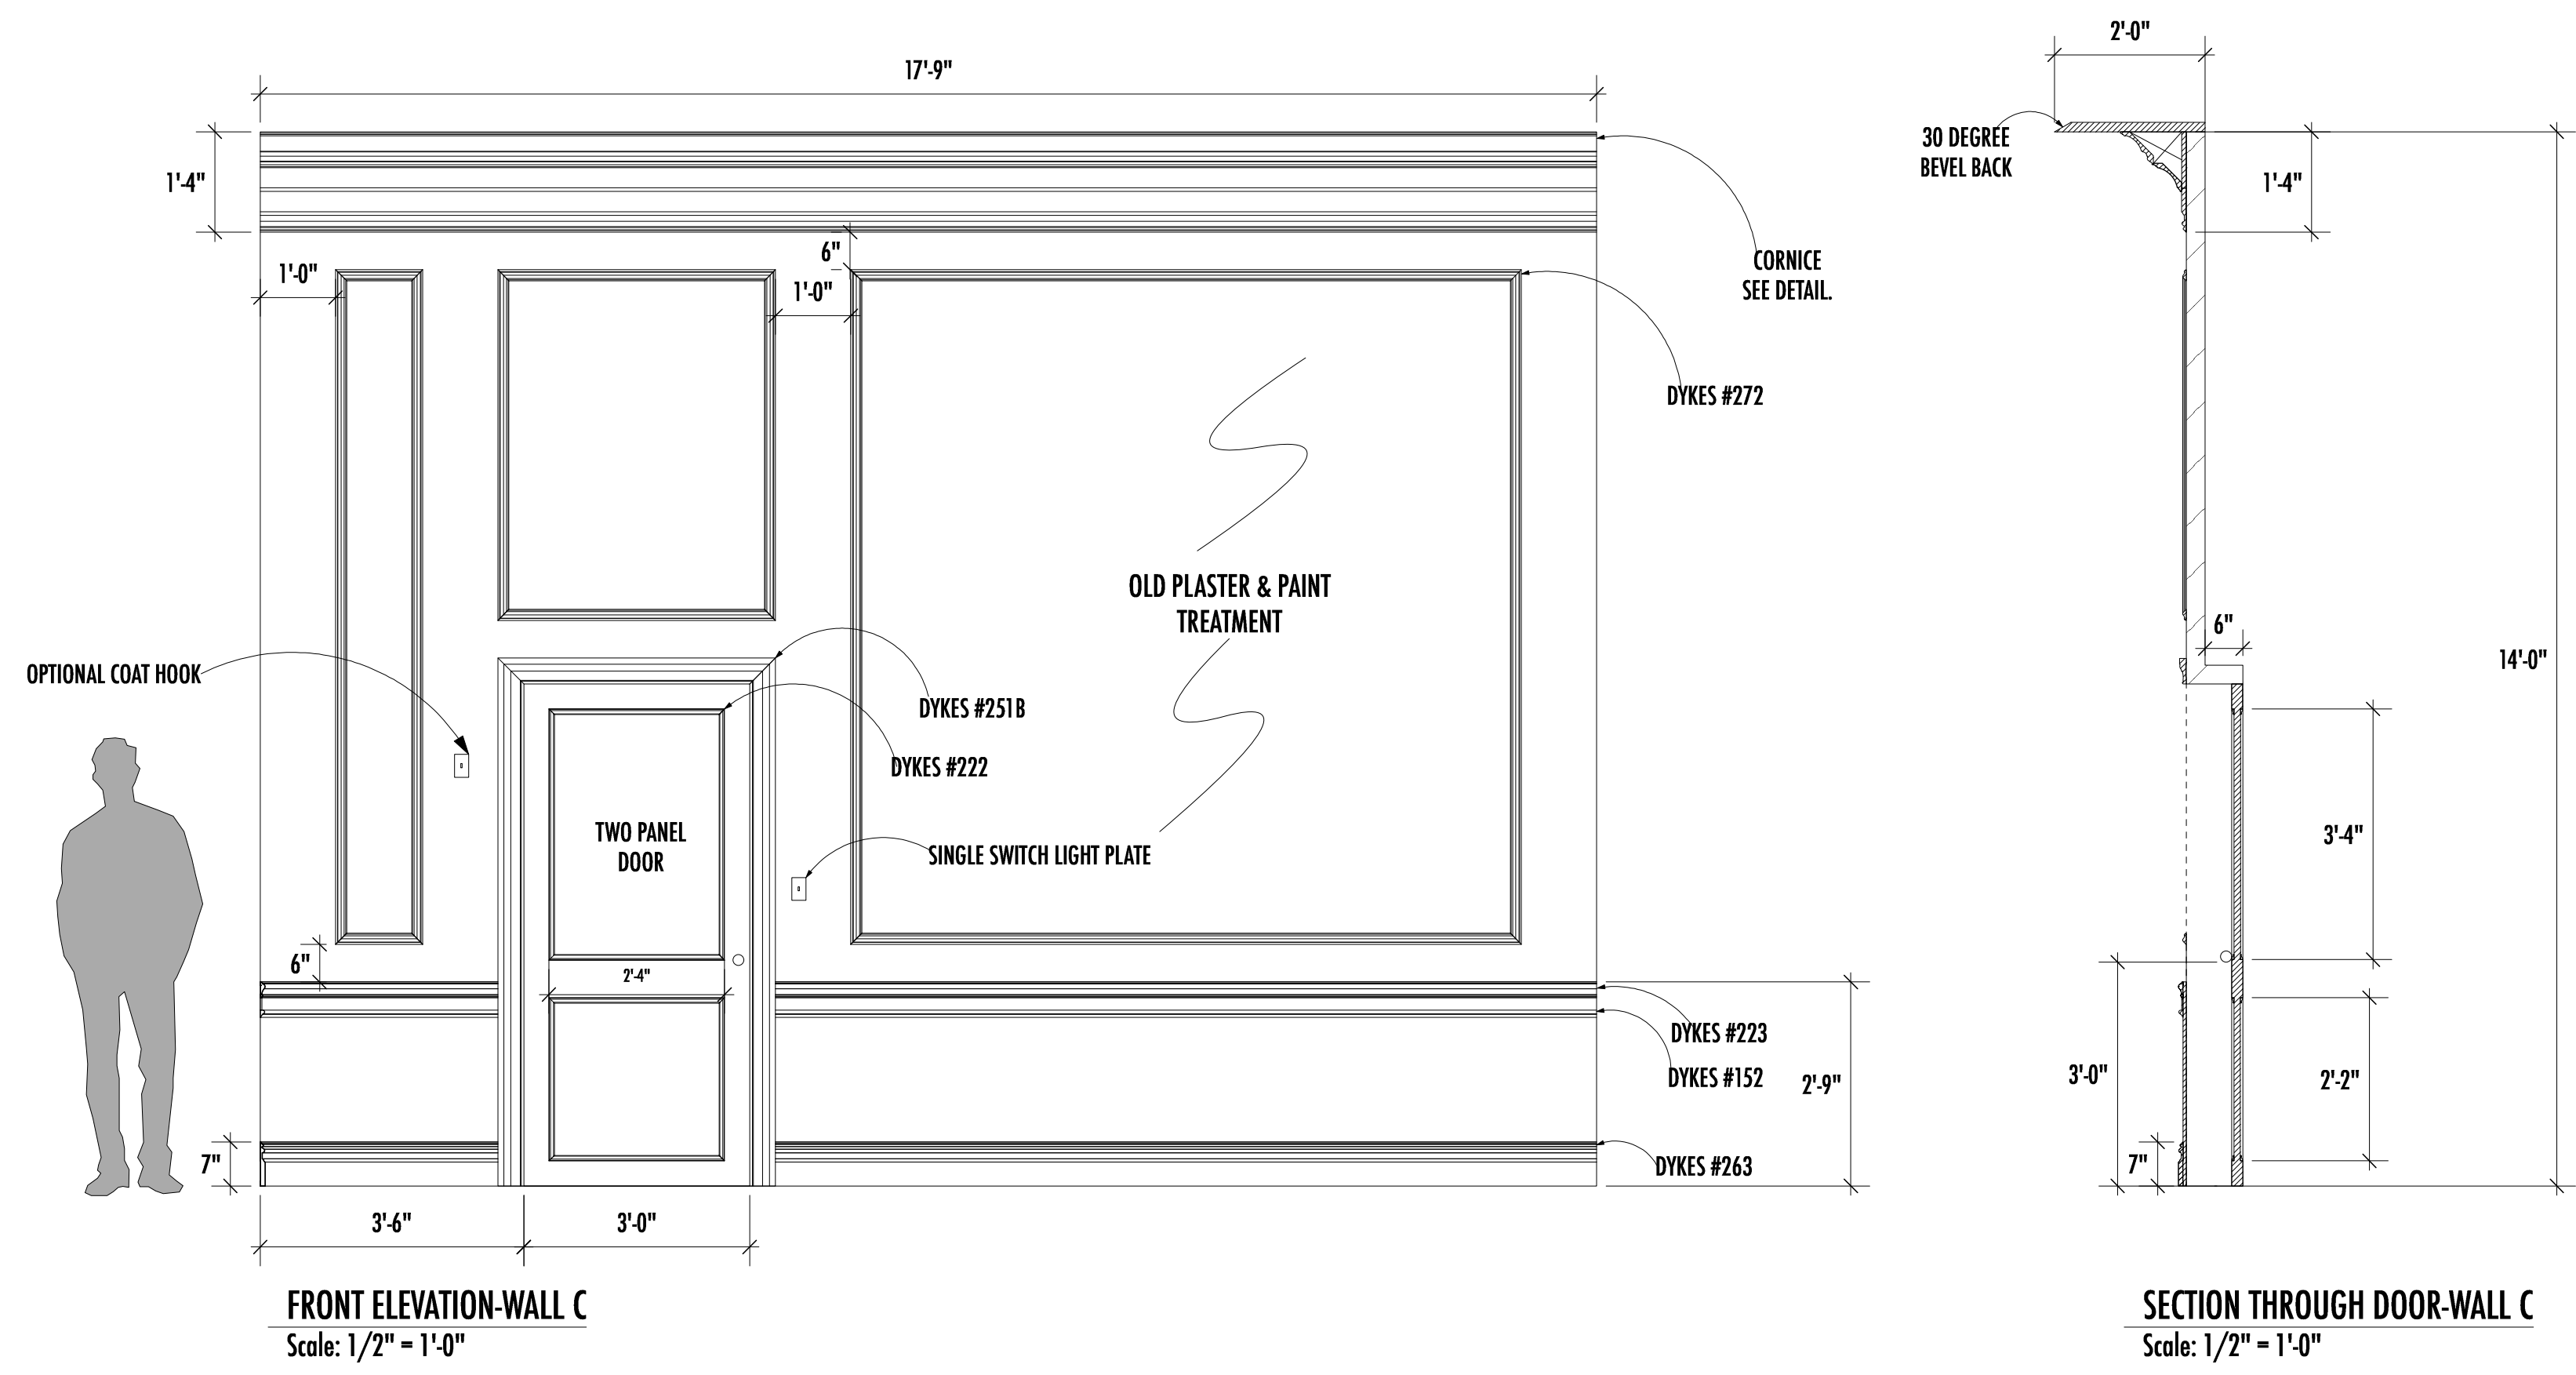

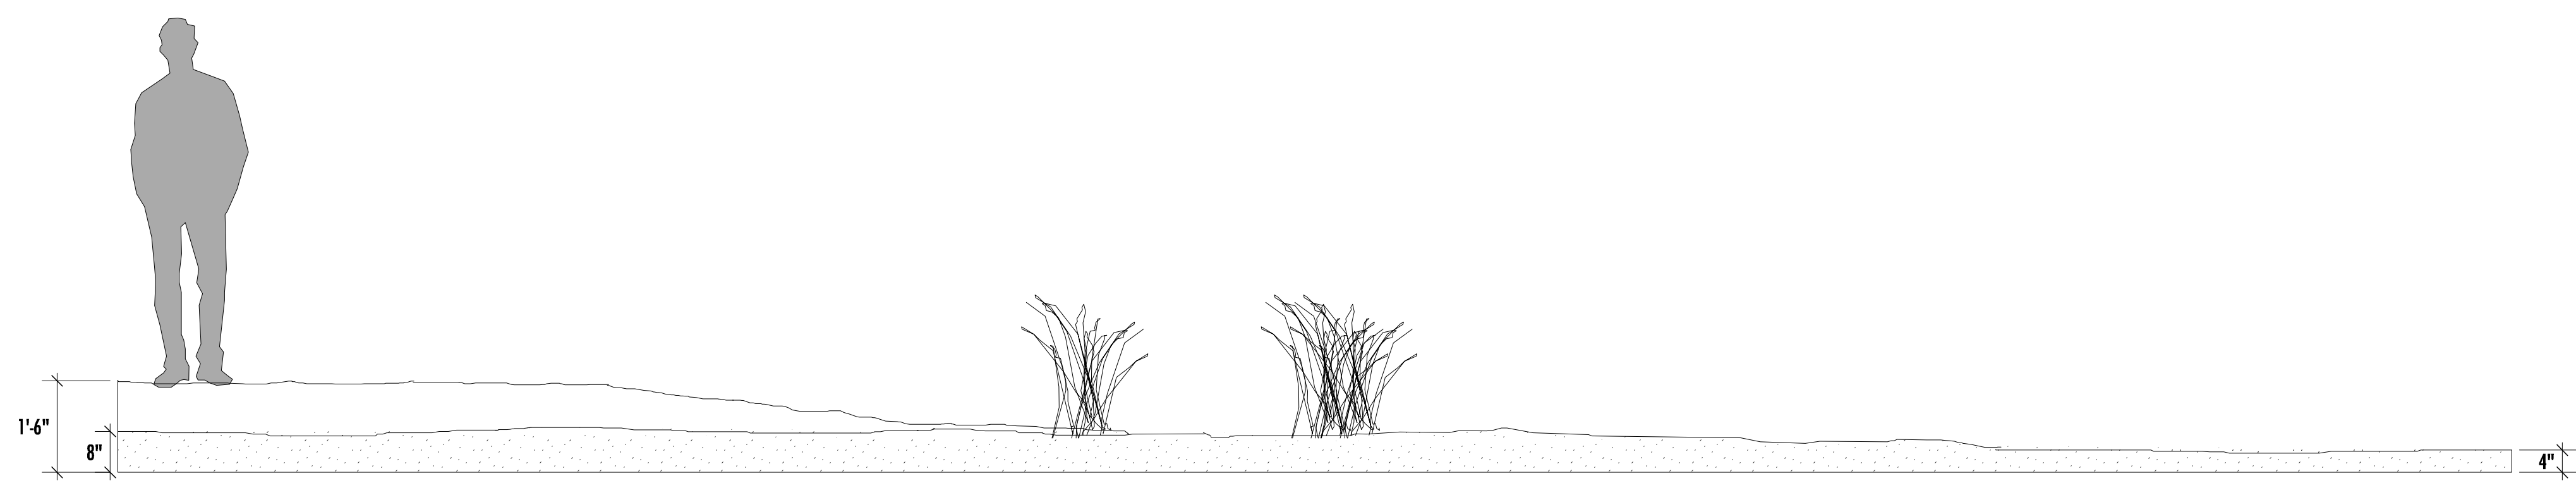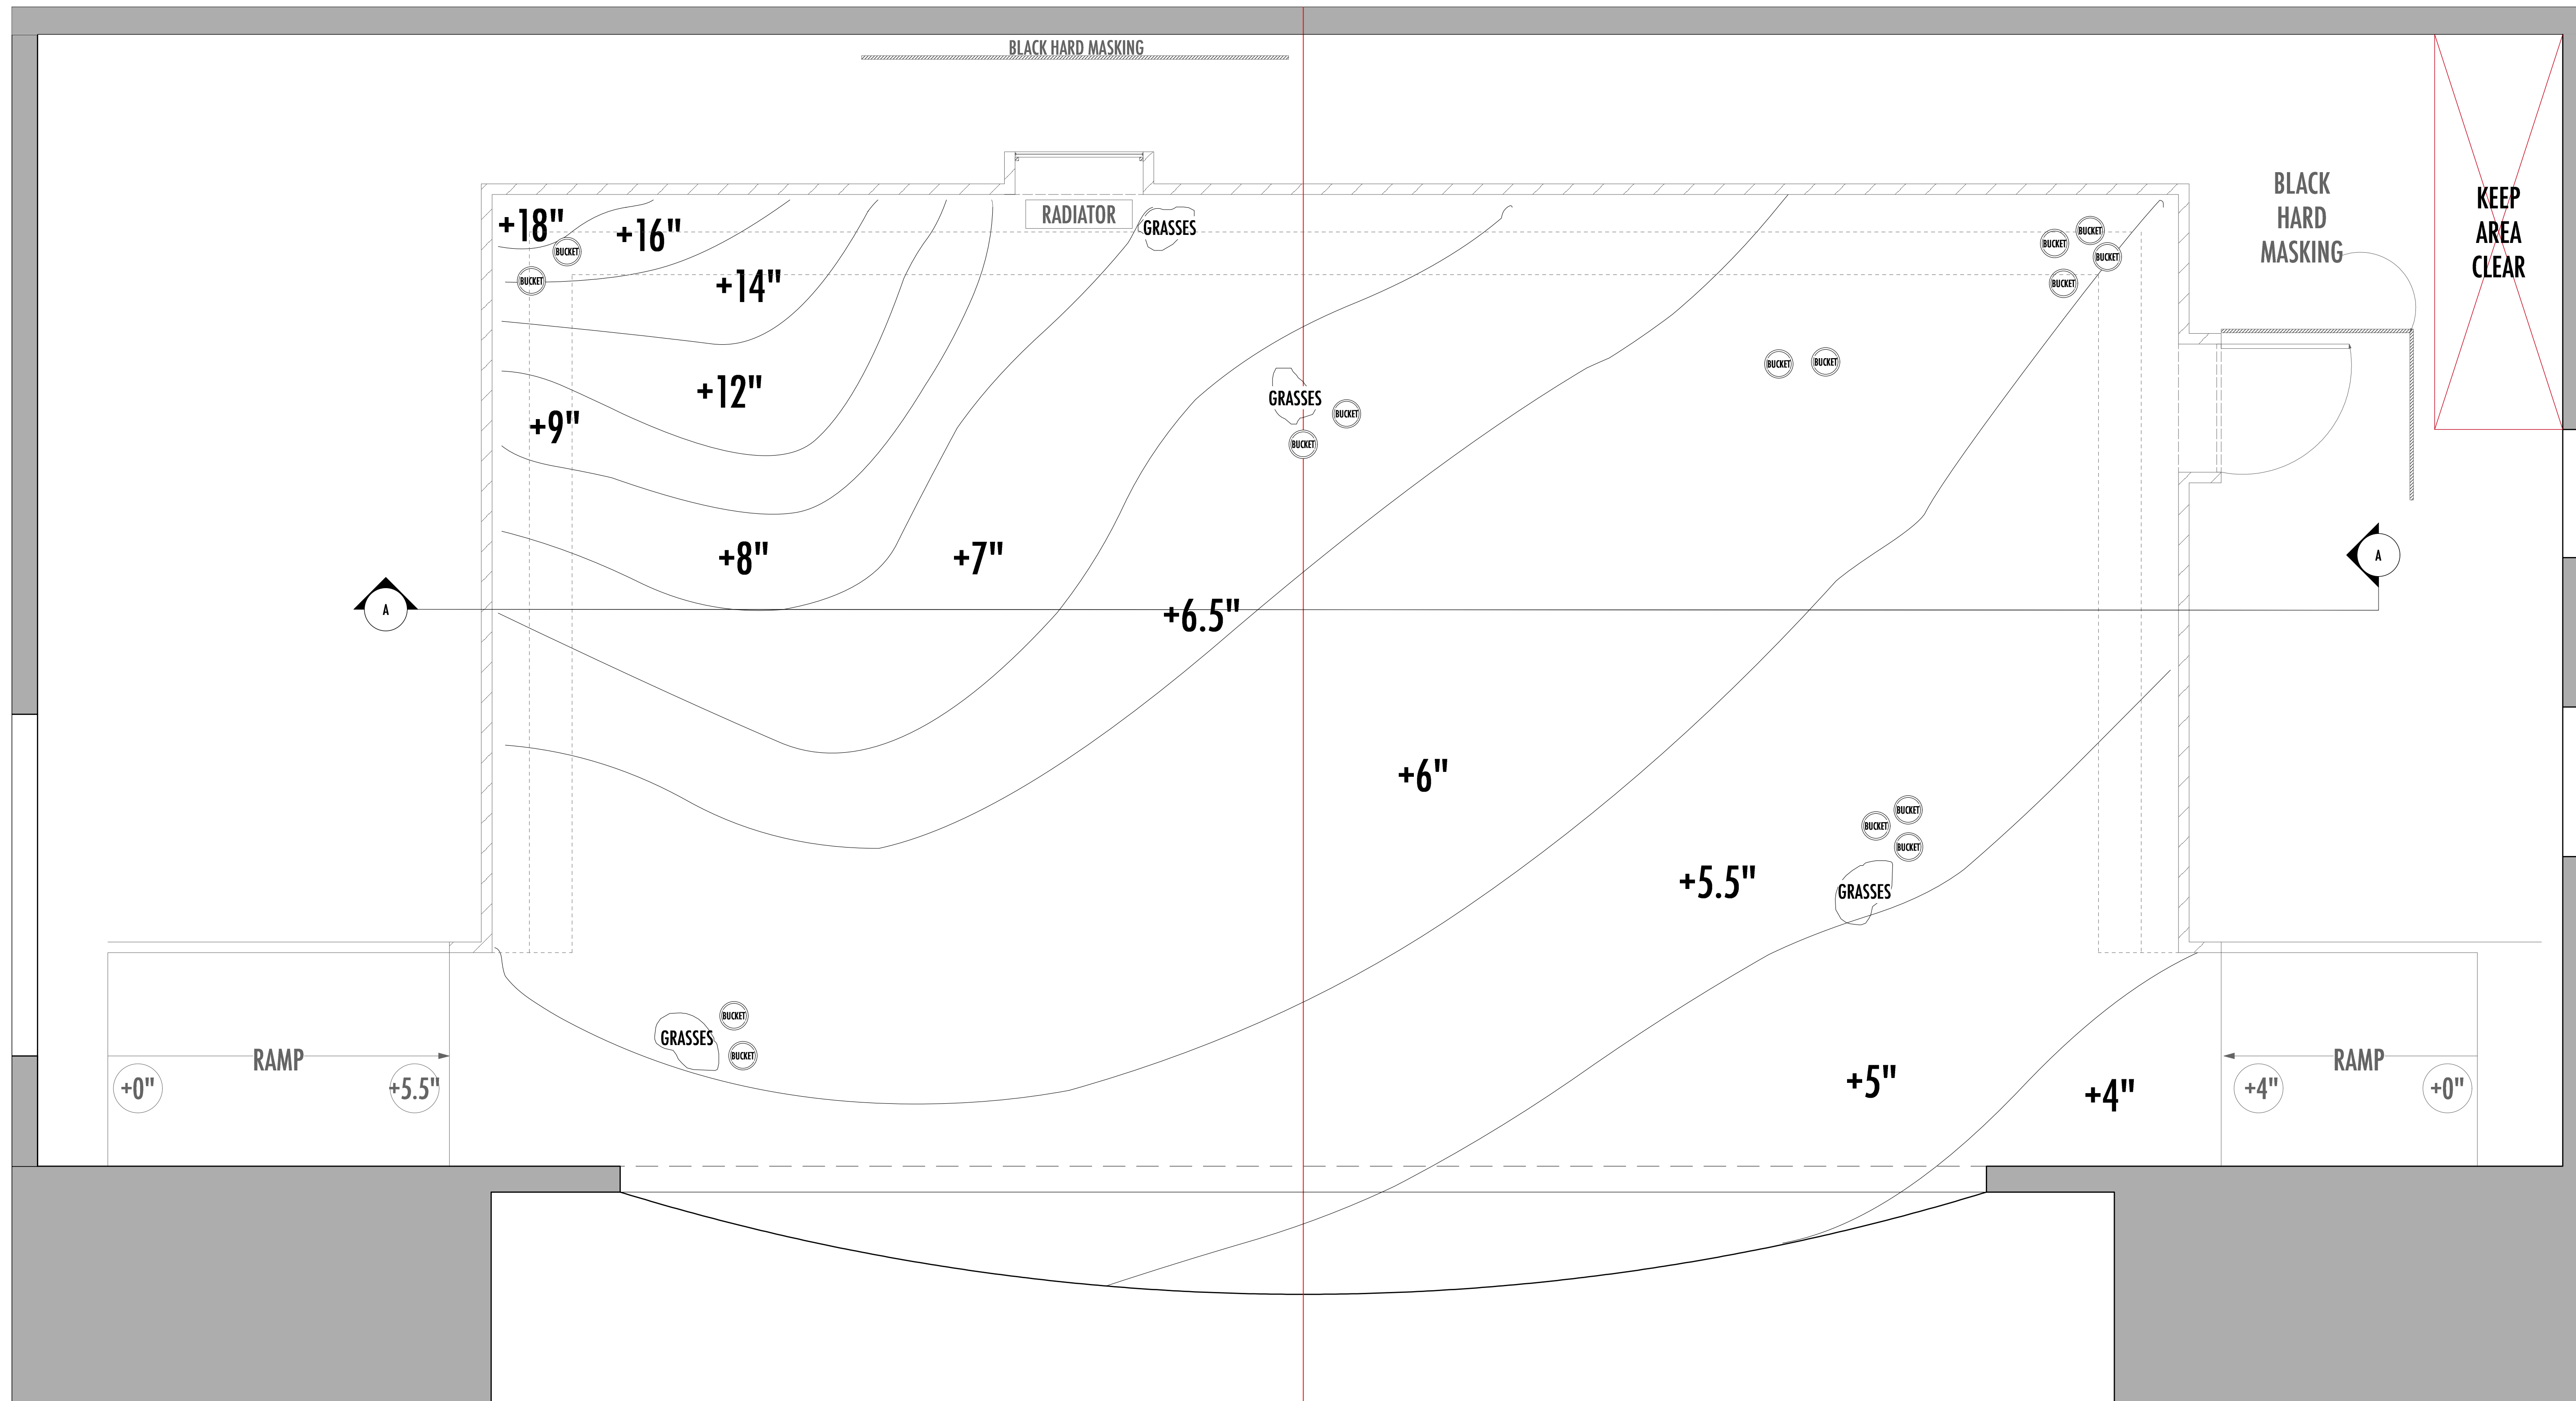

EARTH FLOOR-SECTION THROUGH A
Scale: 1/2" = 1'-0"



917.570.5105
NARELLE@EARTHLINK.NET

OUTSIDE MULLINGAR

BY: JOHN PATRICK SHANLEY
DIRECTED BY: JOHN RUBIN

PRODUCTION TEAM

- SCENIC DESIGNER
NARELLE SISSONS
- LIGHTING DESIGNER
MICHAEL GIANNITTI
- COSTUME DESIGNER
BARBARA BELL
- SOUND DESIGNER
RYAN RUMERY
- MEDIA DESIGNER
KEVIN RAMSER
- TECHNICAL DIRECTOR
KEVIN JOSEPH
- DRAFTINGS BY
JOEY SARNO

The designer is responsible for the visual aspects of the production only, and the specification of the designer's designs relate solely to the appearance of the design and not to matters of safety. The designer agrees to make prompt correcting alterations to any specifications found to be incompatible with proper safety precautions

DORSET THEATRE FESTIVAL

DATE: 04-21-2015

SCALE: 0'-1/2" = 1'-0"

- REVISION #1: 05-01-2015
- REVISION #2: 05-15-2015
- REVISION #3: 05-25-2015

PACKED EARTH DECK LAYOUT

PLATE NO.

